

PEKERJAAN LAYOUT DAN DETAIL KOLAM

DAFTAR GAMBAR
PEKERJAAN KOLAM
DED TAMBAK UPT
PINRANG - SULAWESI SELATAN

NO. LEMBAR	NAMA GAMBAR	NO. GAMBAR	SKALA
○ LAYOUT KOLAM			
	DAFTAR GAMBAR	LDK-00.00	NTS
	LAYOUT PENGUKURAN BATIMETRI	LDK-01.01	1 : 4.000
	LAYOUT PENGUKURAN BATIMETRI OVERLAY CITRA	LDK-01.02	1 : 4.000
	LAYOUT FULL	LDK-02.01	1 : 6.000
	LAYOUT FUL OVERLAY CITRA	LDK-02.02	1 : 6.000
	LAYOUT SITE PLAN KOLAM	LDK-03.01	1 : 1.500
	DETAIL LAYOUT MODUL KOLAM	LDK-04.01	1 : 750
	POTONGAN A - A DAN DETAIL POTONGAN D.1	LDK-04.02	1 : 650
	POTONGAN B - B, DETAIL POTONGAN D.1 & D.2	LDK-04.03	1 : 350 1:50 & 1:25
	POTONGAN C - C, DETAIL POTONGAN D.1 & D.2	LDK-04.04	1 : 350 1:50 & 1:25
	LAYOUT DPT KOLAM	LDK-05.01	1 : 500
	DETAIL LAYOUT MODUL DPT	LDK-06.01	1 : 750
	DETAIL DPT	LDK-06.02	1 : 25
	DETAIL DENAH KOLAM D36	LDK-07.01	1 : 150
	DENAH RENCANA TIANG KOLAM	LDK-07.02	1 : 150
	DENAH RENCANA RESAPAN KOLAM	LDK-07.03	1 : 150
	POTONGAN DAN DETAIL KOLAM	LDK-07.04	1 : 125 1 : 50
	DETAIL PIPA RESAPAN KOLAM	LDK-07.05	1 : 100 1 : 20
	DETAIL DINDING KOLAM	LDK-07.06	1 : 100 1:50 & 1:25
	DETAIL LAMPU KOLAM	LDK-07.07	1 : 50
	DENAH TANGGA DAN POTONGAN MFD	LDK-07.08	1 : 50
	DETAIL PONDASI MFD DAN PONDASI TANGGA	LDK-07.09	1 : 50 1 : 20
	DETAIL MANHOLE 1	LDK-07.10	1 : 20
	DETAIL MANHOLE 2	LDK-07.11	1 : 20
	DETAIL ELEVASI PIPA	LDK-07.12	1 : 20
	DETAIL QUALITY MONITORING	LDK-07.13	1 : 25

PEMBERI TUGAS



KEMENTERIAN KELAUTAN DAN PERIKANAN
DIREKTORAT JENDERAL PERIKANAN BUDI DAYA
INFRASTRUCTURE IMPROVEMENT OF SHRIMP AQUACULTURE PROJECT (ISAP)
JALAN MEDAN MERDEKA TRAJUR NOMOR 16
JAKARTA 10110 KOTAK POS 4190 JKP 10041
TELEPON (021) 551879 (LACAK), FAKS (021) 2514772
LAMPAK www.kkp.go.id SUREL id@kpp.go.id

PEKERJAAN

GAMBAR DETAIL ENGINEERING DESIGN (DED)
TAMBAK UPT

LOKASI

DESA DATA, KEC. DUAM PANUA
KAB. PINRANG, PROV. SULAWESI SELATAN

REVISI

NO	TGL	LOKASI	GMBR	DICEK	DISETUJUI

KONSULTAN PERENCANA



PT. DUTA CIPTA MANDIRI ENGINEERING CONSULTANT
AND IN SUB CONSULTANCY WITH



PT. SUCOFINDO ADVISORY UTAMA



PT. INAME UTAMA



PT. CAKRA BUANA AGHNA

DISUSUN :



Dr. Ir. BAMBANG SUMARTONO, M.Sc.
Aquaculture Specialist (Team Leader) [AQSTL]


DISETUJUI :

PEJABAT PEMBUAT KOMITMEN
INFRASTRUCTURE IMPROVEMENT OF SHRIMP AQUACULTURE PROJECT



SOLEHUDIN ABDUL GANI, S.Pi
NIP. 19700727 200112 1 001

JUDUL GAMBAR	SKALA	
DAFTAR ISI	NTS	
KODE GAMBAR	HAL GAMBAR	TAHUN
LDK-00.00	-	2024

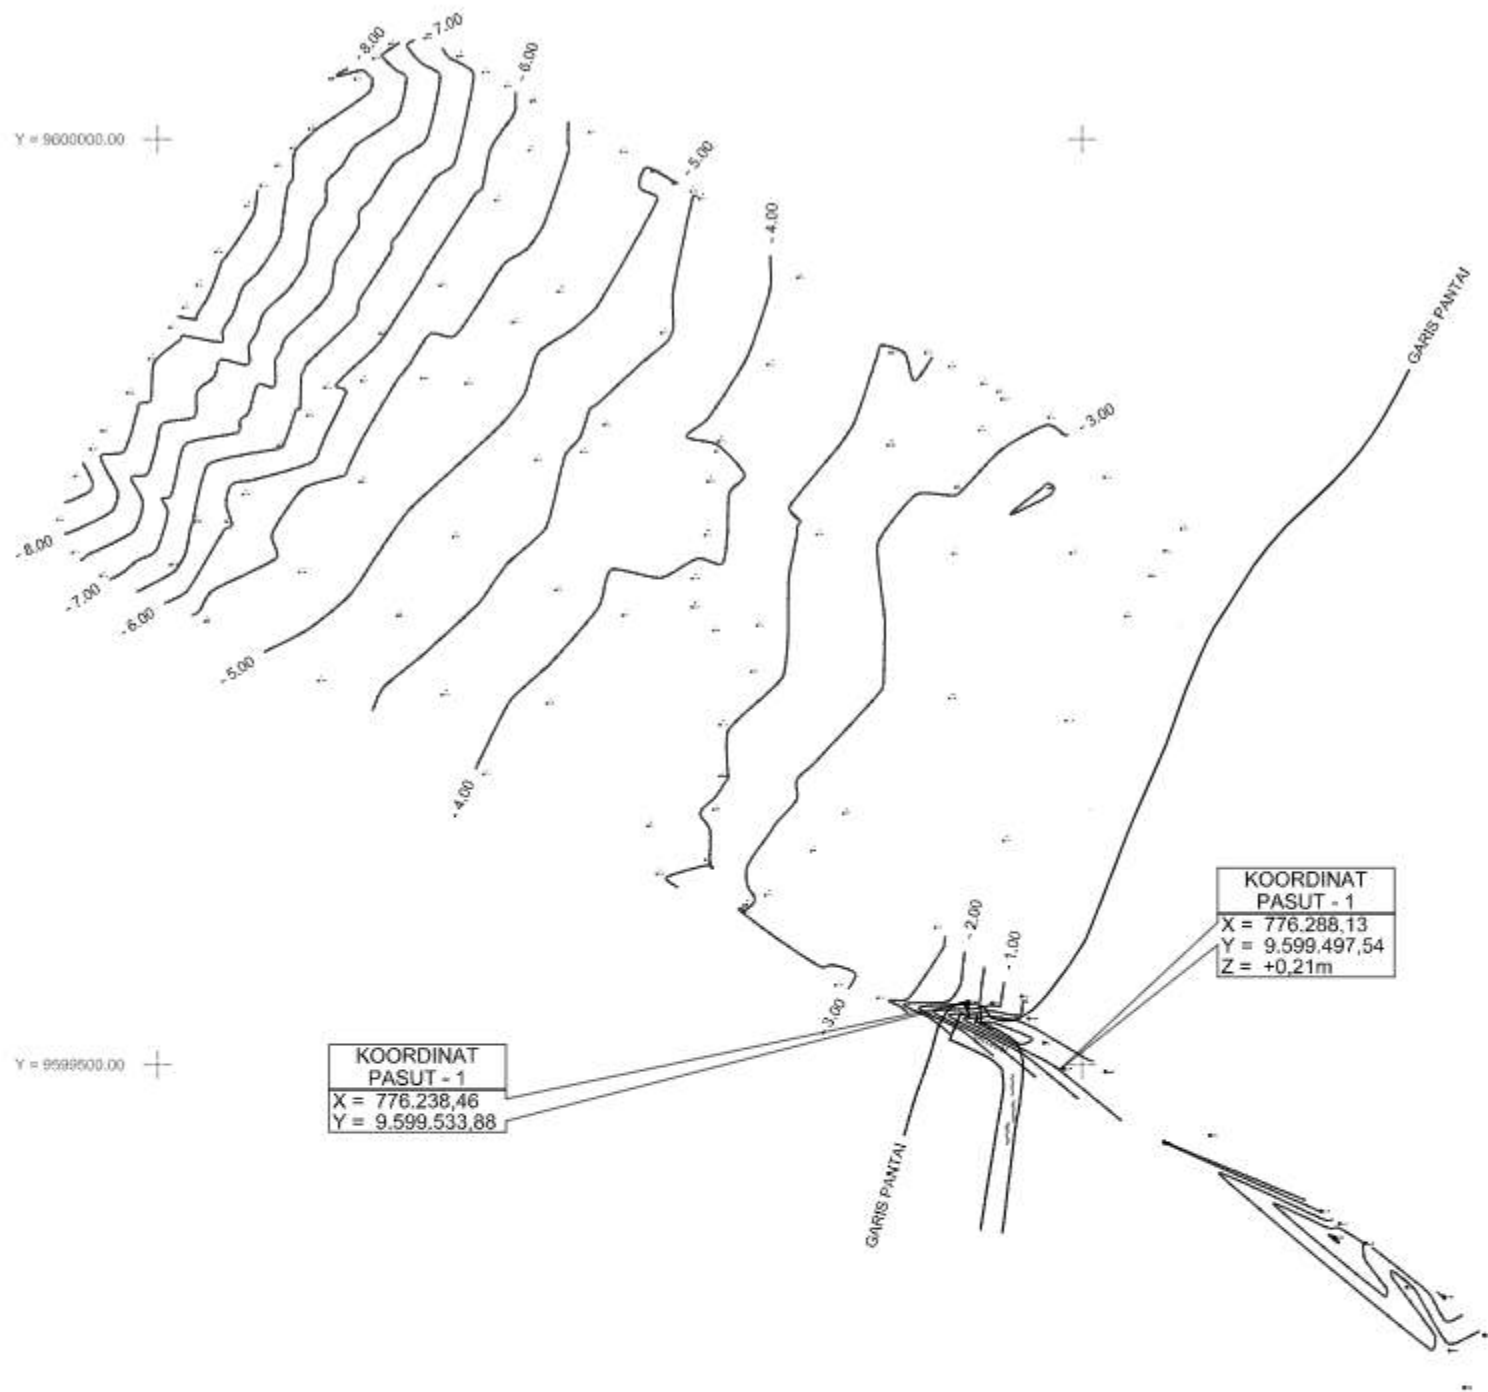

LAYOUT PENGUKURAN BATIMETRI

SKALA 1 : 4.000



Y = 9598000.00
X = 775900.00

X = 776300.00

X = 776800.00

PEMBERI TUGAS



KEMENTERIAN KELAUTAN DAN PERIKANAN
DIREKTORAT JENDERAL PERIKANAN BUDI DAYA
INFRASTRUCTURE IMPROVEMENT OF SHRIMP AQUACULTURE PROJECT (ISAP)
JALAN MEDAN MERDEKA TIMUR NOMOR 16
JAKARTA 10110 KOTAK POS 4100 JKP 10041
TELEPON (021) 3518079 LACAK, FAKSIMILE (021) 9514772
LAMPAH www.kkp.go.id SURTEL d3@kcpa@kcp.go.id

PEKERJAAN

GAMBAR DETAIL ENGINEERING DESIGN (DED)
TAMBAK UPT

LOKASI

DESA DATA, KEC. DUAM PANUA
KAB. PINRANG, PROV. SULAWESI SELATAN

REVISI

NO	TGL	LOKASI	GMBR	DICEK	DISETUJUI

KONSULTAN PERENCANA



PT. DUTA CIPTA MANDIRI ENGINEERING CONSULTANT

AND IN SUB CONSULTANCY WITH



PT. SUCOFINDO ADVISORY UTAMA



PT. INAME UTAMA



PT. CAKRA BUANA AGHNA

DISUSUN :


Dr. Ir. BAMBANG SUMARTONO, M.Sc.
Aquaculture Specialist (Team Leader) (AQSTL)

DISETUJUI :

PEJABAT PEMBUAT KOMITMEN
INFRASTRUCTURE IMPROVEMENT OF SHRIMP AQUACULTURE PROJECT

SOLEHUDIN ABDUL GANI, S.Pi
NIP. 19700727 200112 1 001


JUDUL GAMBAR		SKALA
PETA PENGUKURAN BATIMETRI		1 : 4.000
KODE GAMBAR	HAL. GAMBAR	TAHUN
LDK-01.01	-	2024

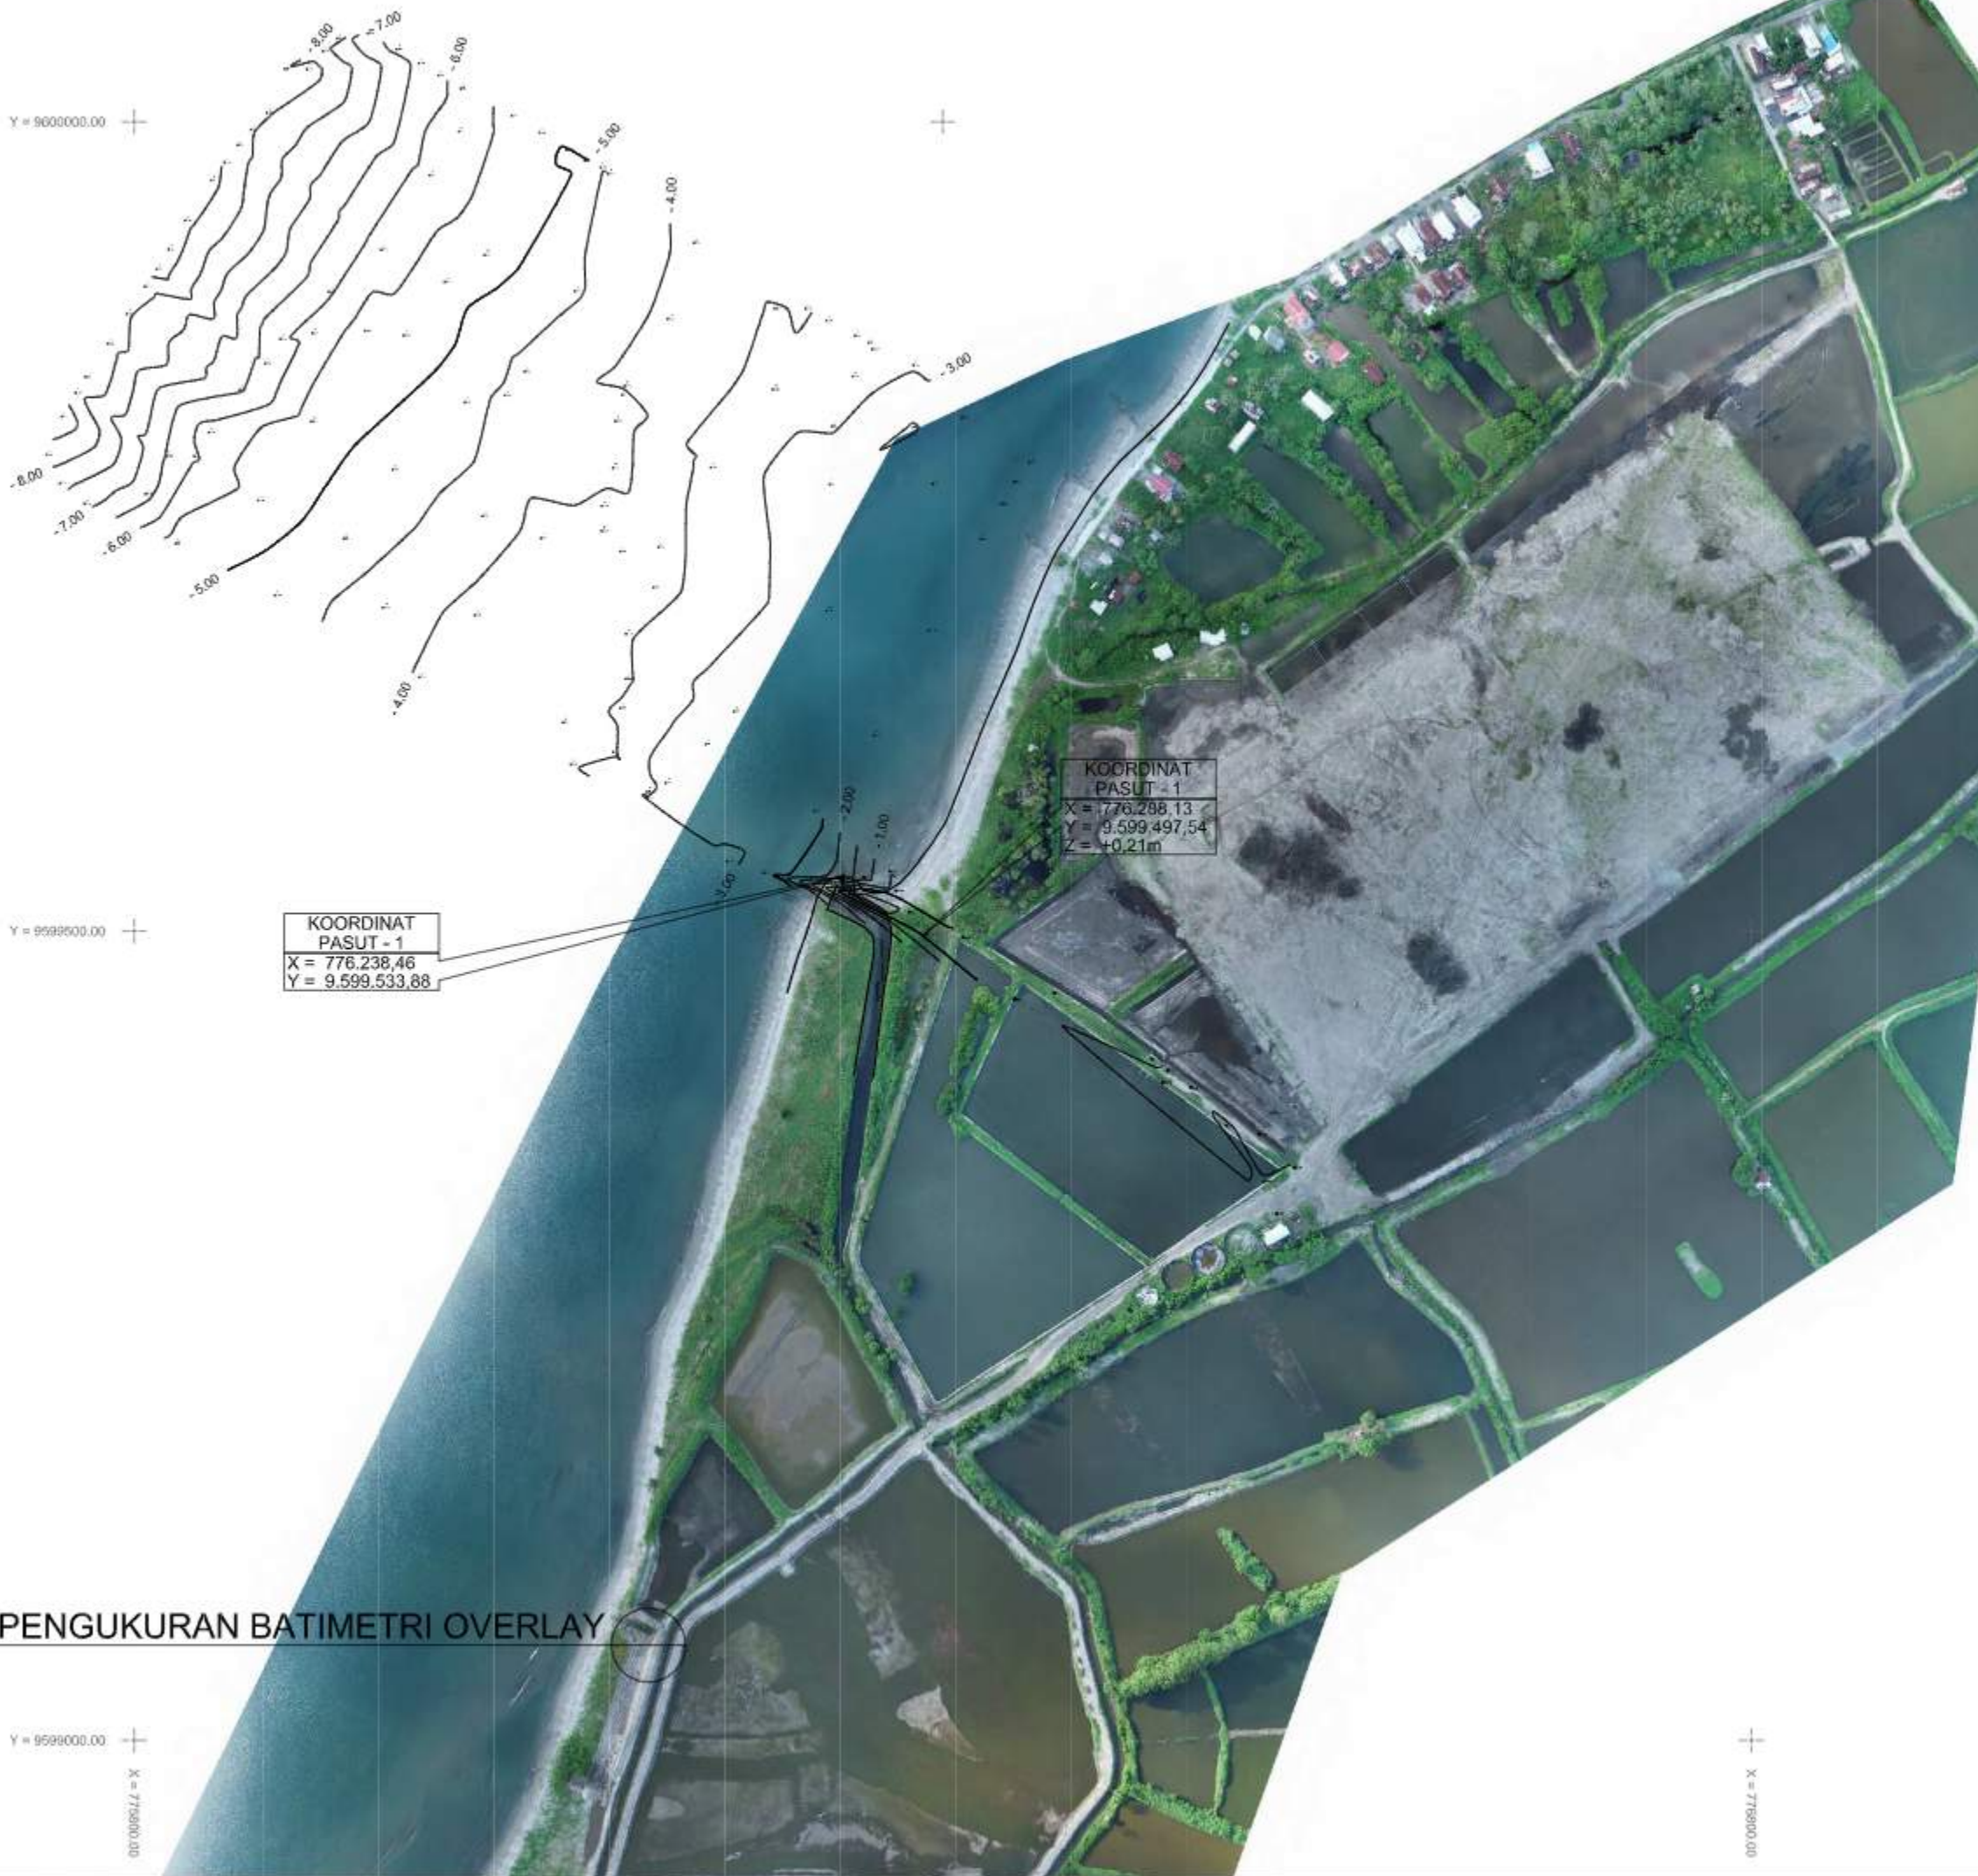

LAYOUT PENGUKURAN BATIMETRI OVERLAY

SKALA 1 : 4.000

PEMBERI TUGAS					
 KEMENTERIAN KELAUTAN DAN PERIKANAN DIREKTORAT JENDERAL PERIKANAN BUDI DAYA INFRASTRUCTURE IMPROVEMENT OF SHRIMP AQUACULTURE PROJECT (ISAP) JALAN MEDAN MERDEKA TIMUR NOMOR 16 JAKARTA 10110 KOTAK POS 4100 JKP 10041 TELEPON (021) 3518079 LACAK, FAKSIMILE (021) 9514772 LAMPAH www.kkp.go.id SURTEL d3@kpa@knp.go.id					
PEKERJAAN					
GAMBAR DETAIL ENGINEERING DESIGN (DED) TAMBAK UPT					
LOKASI					
DESA DATA, KEC. DUAM PANUA KAB. PINRANG, PROV. SULAWESI SELATAN					
REVISI					
NO	TGL	LOKASI	GMBR	DICEK	DISETUJUI
KONSULTAN PERENCANA					
 PT. DUTA Cipta MANDIRI ENGINEERING CONSULTANT AND IN SUB CONSULTANCY WITH  PT. SUCOFINDO ADVISORY UTAMA  PT. INAME UTAMA  PT. CAKRA BUANA AGHNA					
DISUSUN :					
 Dr. Ir. BAMBANG SUMARTONO, M.Sc. Aquaculture Specialist (Team Leader) (AQST/L)					
DISETUJUI :					
PEJABAT PEMBUAT KOMITMEN INFRASTRUCTURE IMPROVEMENT OF SHRIMP AQUACULTURE PROJECT  SOLEHUDIN ABDUL GANI, S.Pi NIP. 19700727 200112 1 001					
JUDUL GAMBAR			SKALA		
PETA PENGUKURAN BATIMETRI OVERLAY CITRA			1 : 4.000		
KODE GAMBAR	HPL GAMBAR	TAHUN			
MP-01.01	-	2024			

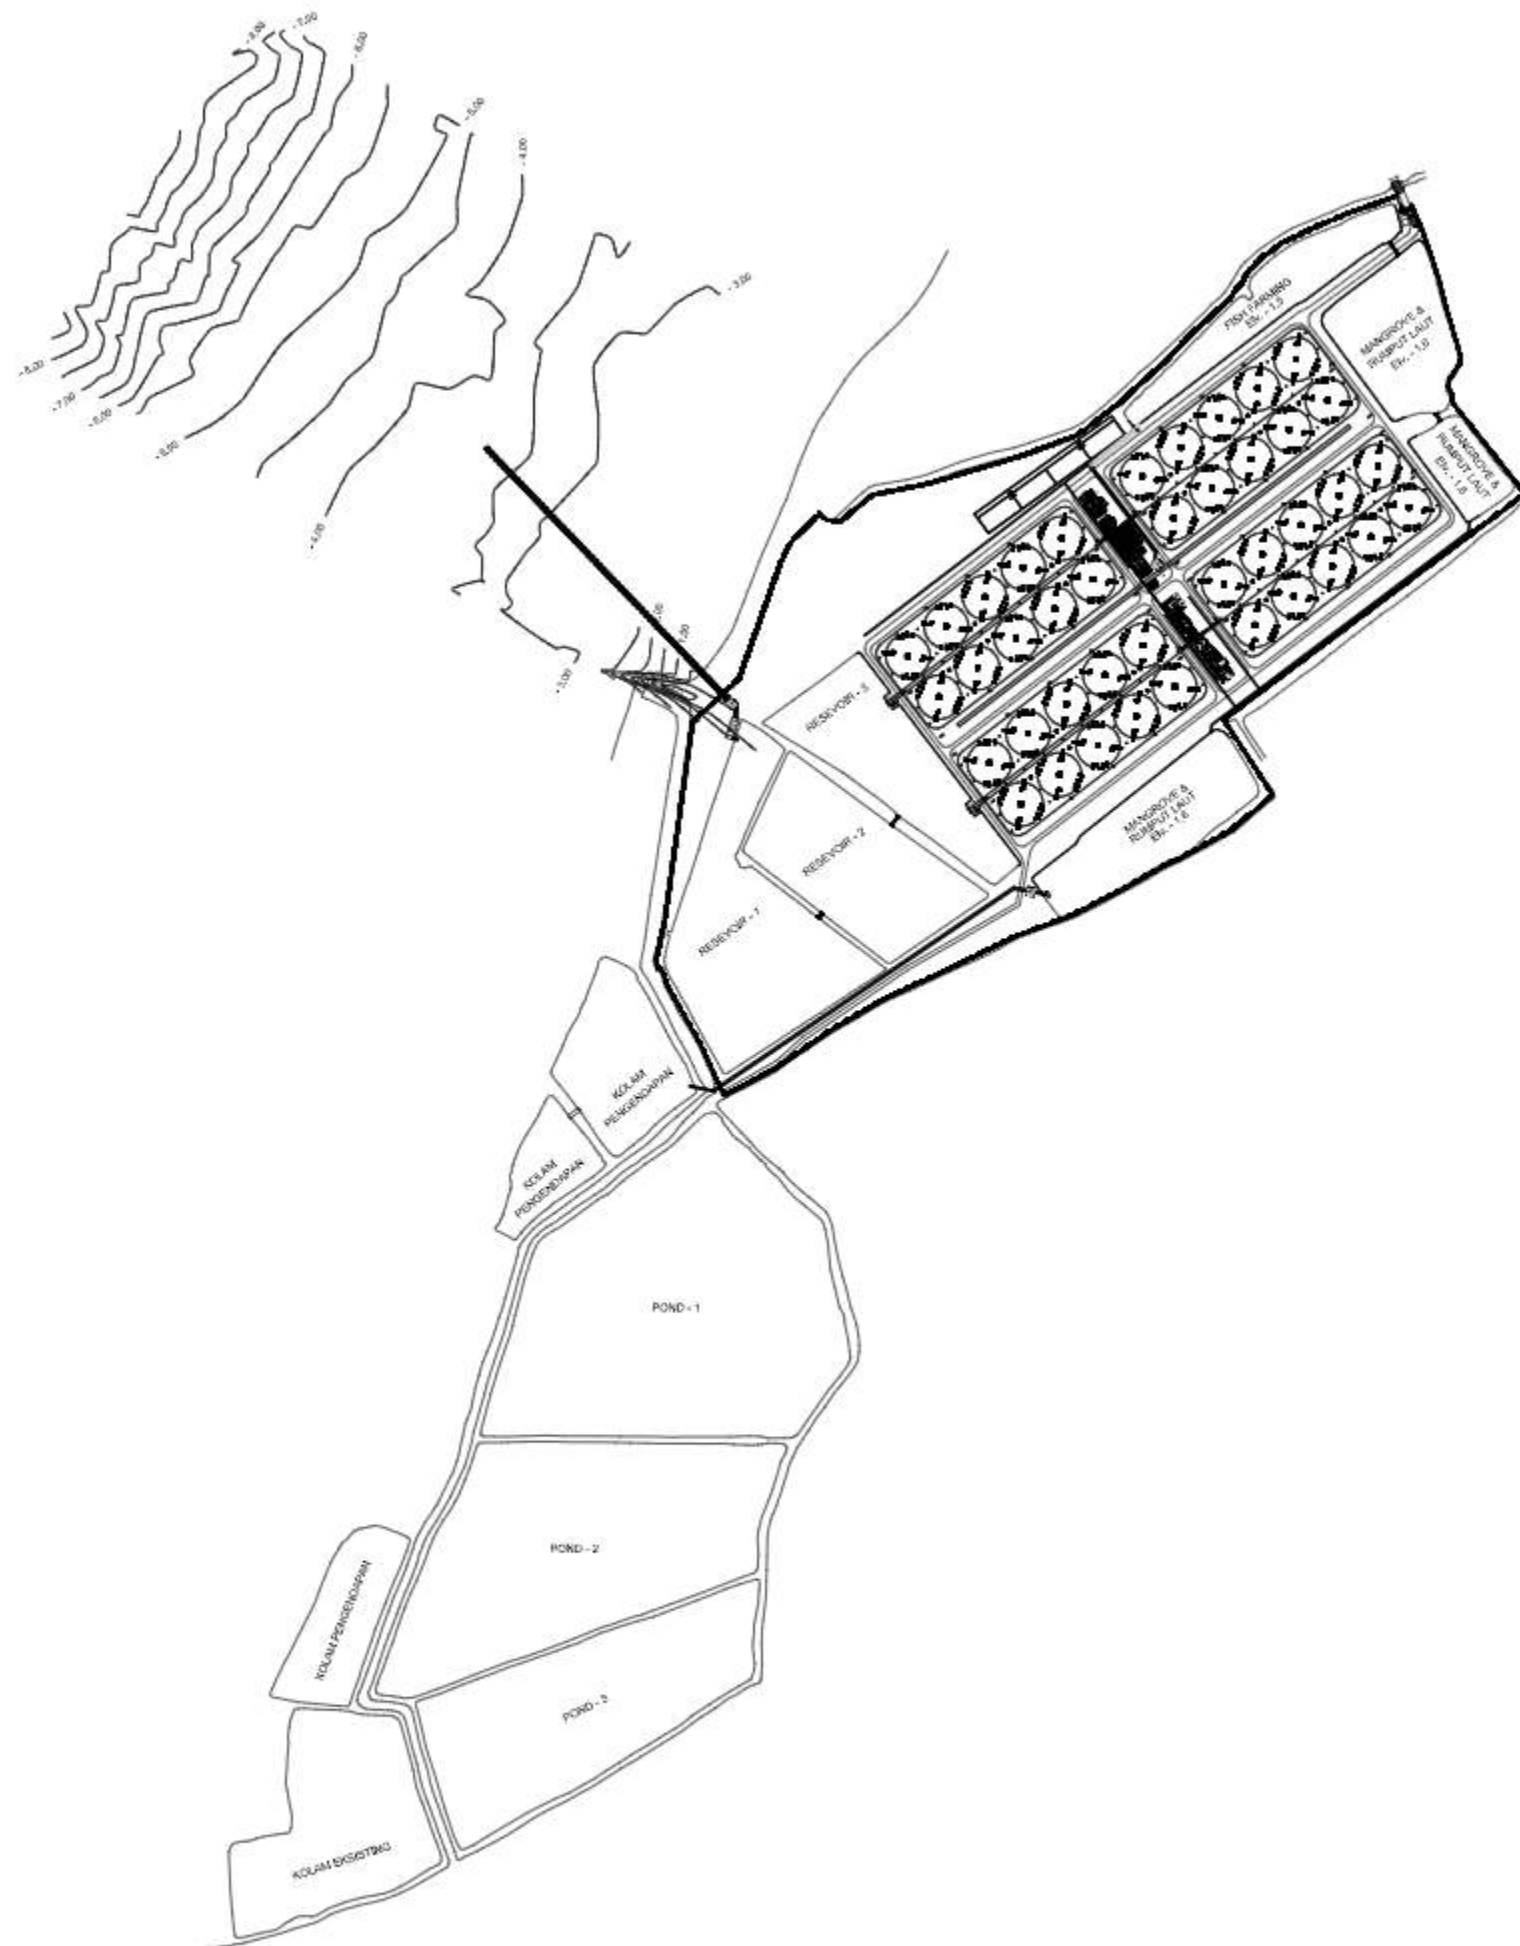

LAYOUT FULL
SKALA 1 : 6.000



PEMBERI TUGAS



KEMENTERIAN KELAUTAN DAN PERIKANAN
DIREKTORAT JENDERAL PERIKANAN BUDI DAYA
INFRASTRUCTURE IMPROVEMENT OF SHRIMP AQUACULTURE PROJECT (ISAP)
JALAN MEDAN MERDEKA TIMUR NOMOR 16
JAKARTA 10110 KOTAK POS 4100 JKP 10041
TELEPON (021) 3518079 LACAK, FAKSIMILE (021) 3514772
LAMPAH www.kkp.go.id SURTEL d@kppa@kpp.go.id

PEKERJAAN

GAMBAR DETAIL ENGINEERING DESIGN (DED)
TAMBAK UPT

LOKASI

DESA DATA, KEC. DUAM PANUA
KAB. PINRANG, PROV. SULAWESI SELATAN

REVISI

NO	TGL	LOKASI	GMBR	DICEK	DISETUJUI

KONSULTAN PERENCANA



PT. DUTA CIPTA MANDIRI ENGINEERING CONSULTANT

AND IN SUB CONSULTANCY WITH



PT. SUCOFINDO ADVISORY UTAMA



PT. INAME UTAMA



PT. CAKRA BUANA AGHNA

DISUSUN :


Dr. Ir. BAMBANG SUMARTONO, M.Sc.
Aquaculture Specialist (Team Leader) (AQST/L)

DISETUJUI :

PEJABAT PEMBUAT KOMITMEN
INFRASTRUCTURE IMPROVEMENT OF SHRIMP AQUACULTURE PROJECT

SOLEHUDIN ABDUL GANI, S.Pi
NIP. 19700727 200112 1 001

JUDUL GAMBAR		SKALA
LAYOUT FULL		1 : 6.000
KODE GAMBAR	HAL GAMBAR	TAHUN
LDK-02.01	-	2024

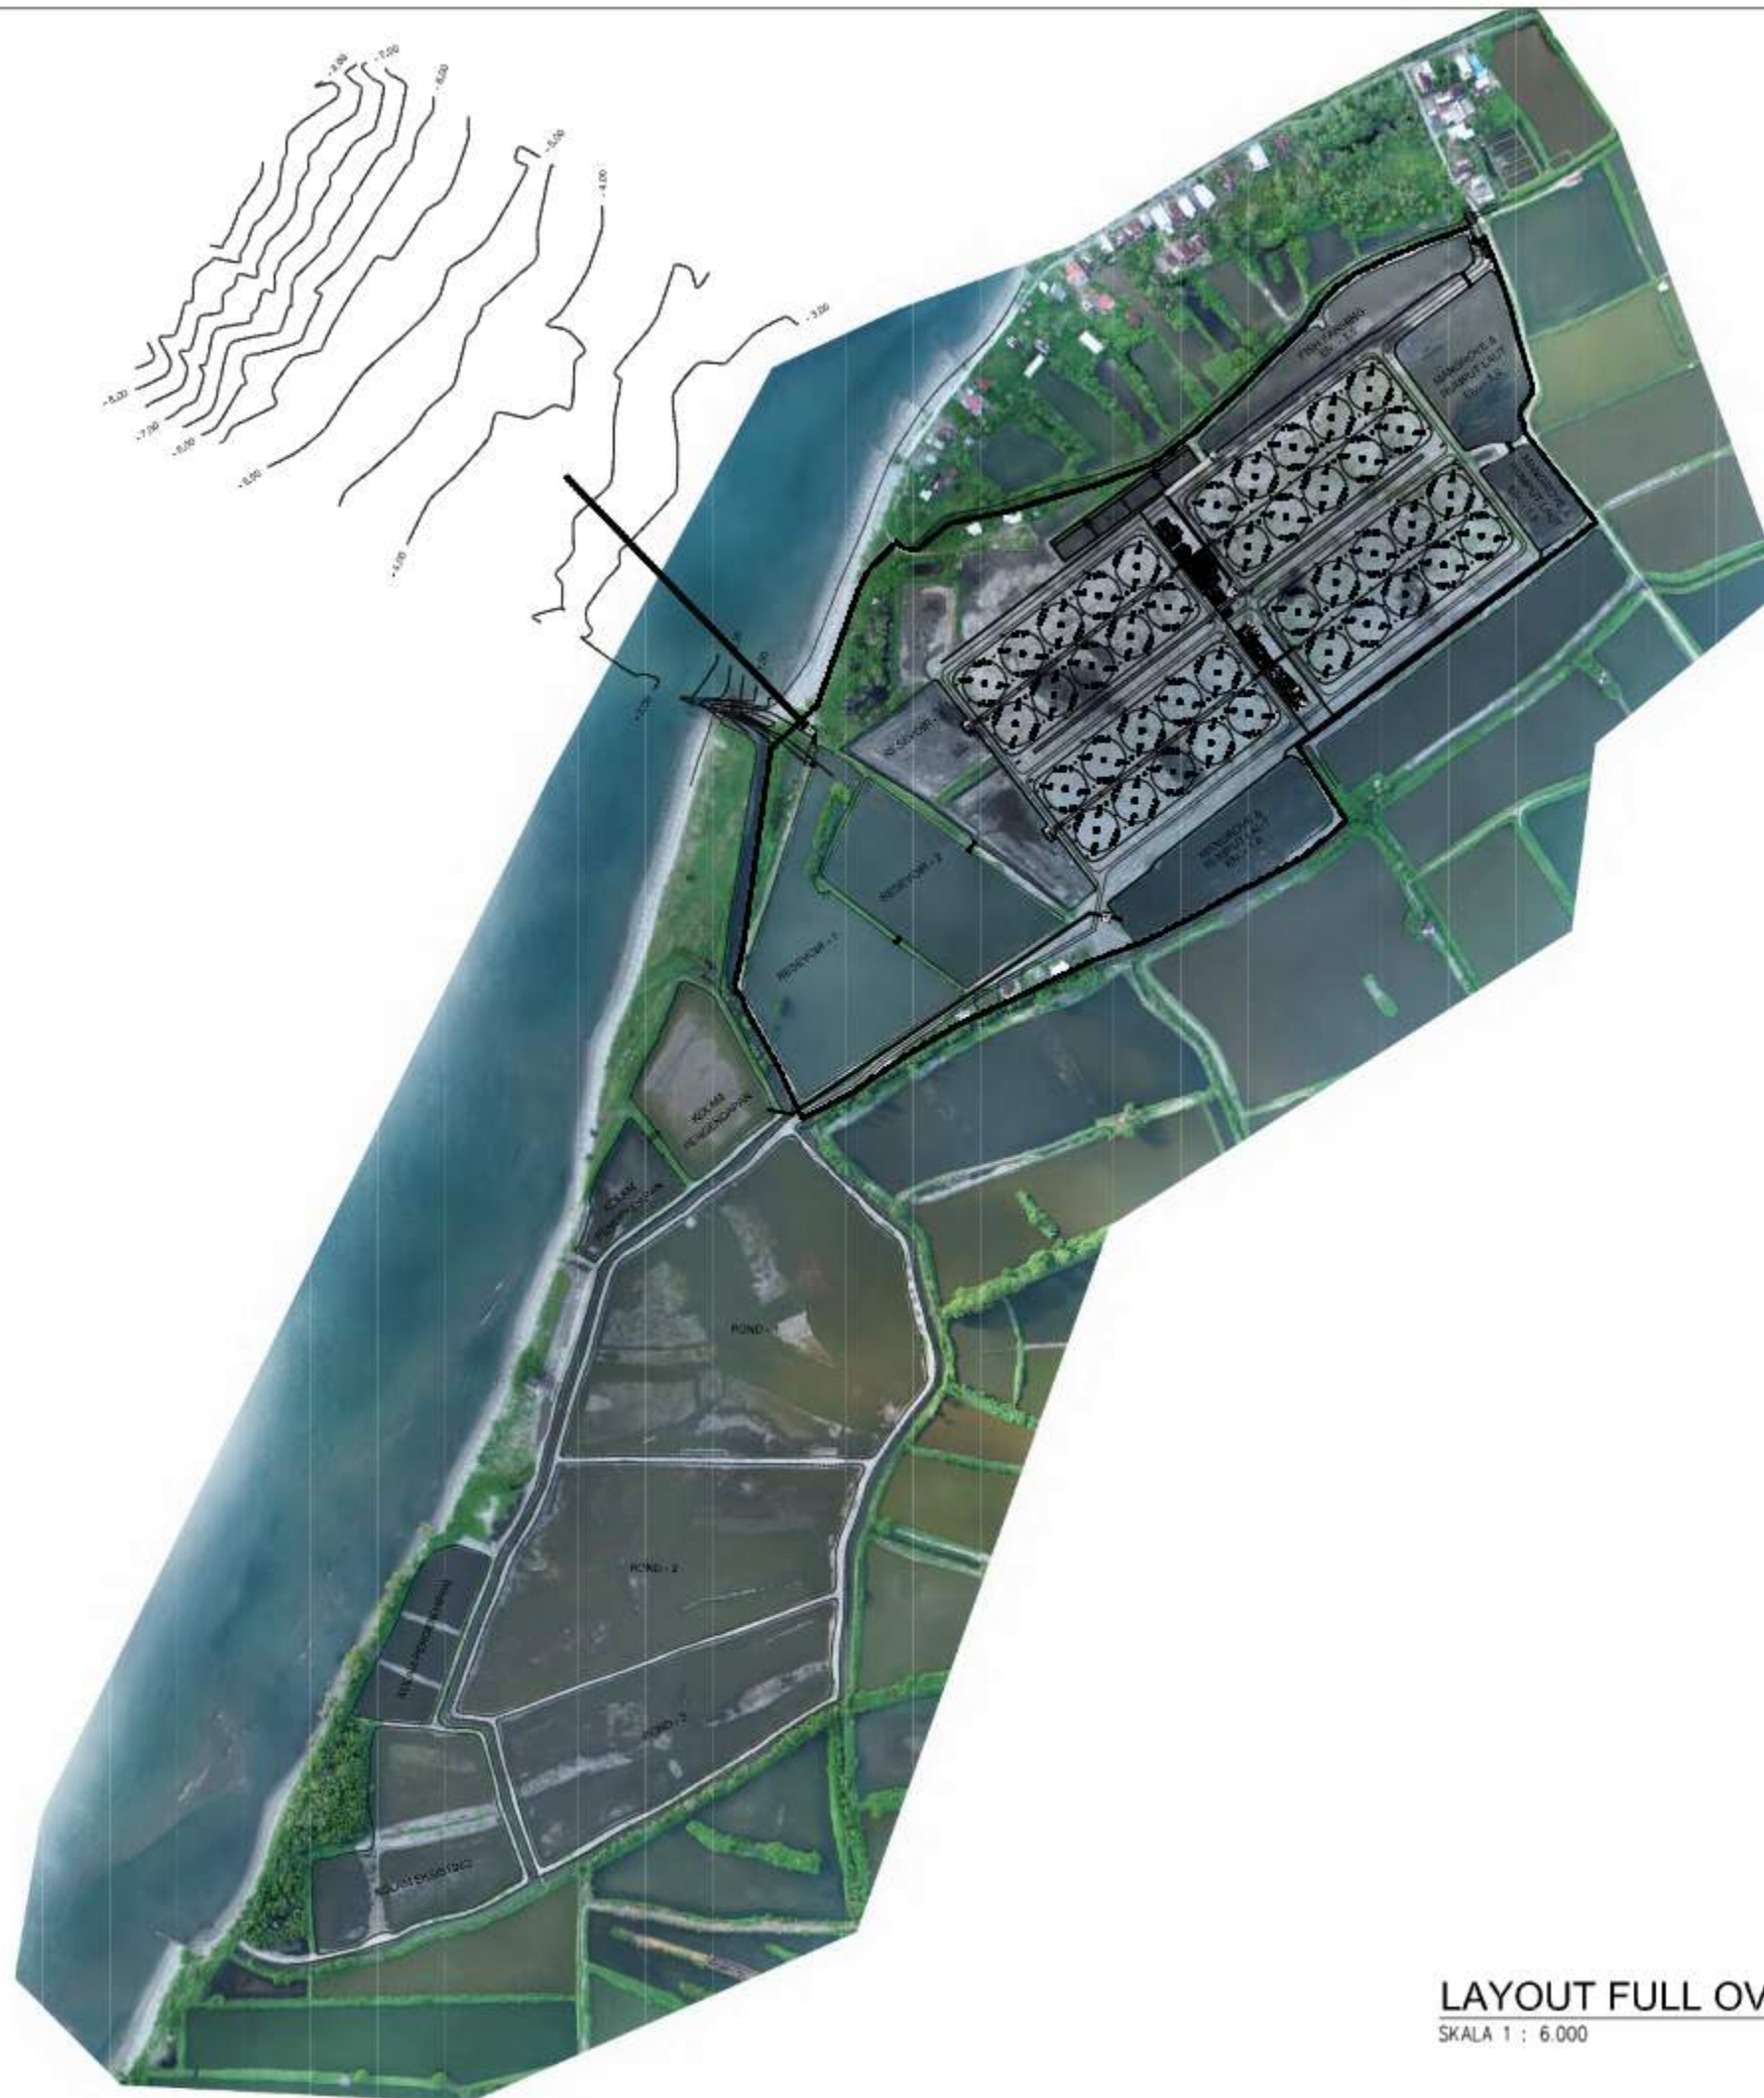

LAYOUT FULL OVERLAY CITRA
SKALA 1 : 6.000

PEMBERI TUGAS



KEMENTERIAN KELAUTAN DAN PERIKANAN
DIREKTORAT JENDERAL PERIKANAN BUDI DAYA
INFRASTRUCTURE IMPROVEMENT OF SHRIMP AQUACULTURE PROJECT (ISAP)
JALAN MEDAN MERDEKA TIMUR NOMOR 16
JAKARTA 10110 KOTAK POS 4100 JKP 10041
TELEPON (021) 3518079 LACAK, FAKSIMILE (021) 3514772
LAMPAH www.kkp.go.id SURTEL d@kppa@kpp.go.id

PEKERJAAN

GAMBAR DETAIL ENGINEERING DESIGN (DED)
TAMBAK UPT

LOKASI

DESA DATA, KEC. DUAM PANUA
KAB. PINRANG, PROV. SULAWESI SELATAN

REVISI

NO	TGL	LOKASI	GMBR	DICEK	DISETUJUI

KONSULTAN PERENCANA



PT. DUTA CIPTA MANDIRI ENGINEERING CONSULTANT

AND IN SUB CONSULTANCY WITH



PT. SUCOFINDO ADVISORY UTAMA



PT. INAME UTAMA



PT. CAKRA BUANA AGHNA

DISUSUN :


Dr. Ir. BAMBANG SUMARTONO, M.Sc.
Aquaculture Specialist (Team Leader) (AQS/TL)

DISETUJUI :

PEJABAT PEMBUAT KOMITMEN
INFRASTRUCTURE IMPROVEMENT OF SHRIMP AQUACULTURE PROJECT

SOLEHUDIN ABDUL GANI, S.Pi
NIP. 19700727 200112 1 001

JUDUL GAMBAR		SKALA
LAYOUT FULL OVERLAY CITRA		1 : 6.000
KODE GAMBAR	HAL GAMBAR	TAHUN
LDK-02.02	-	2024

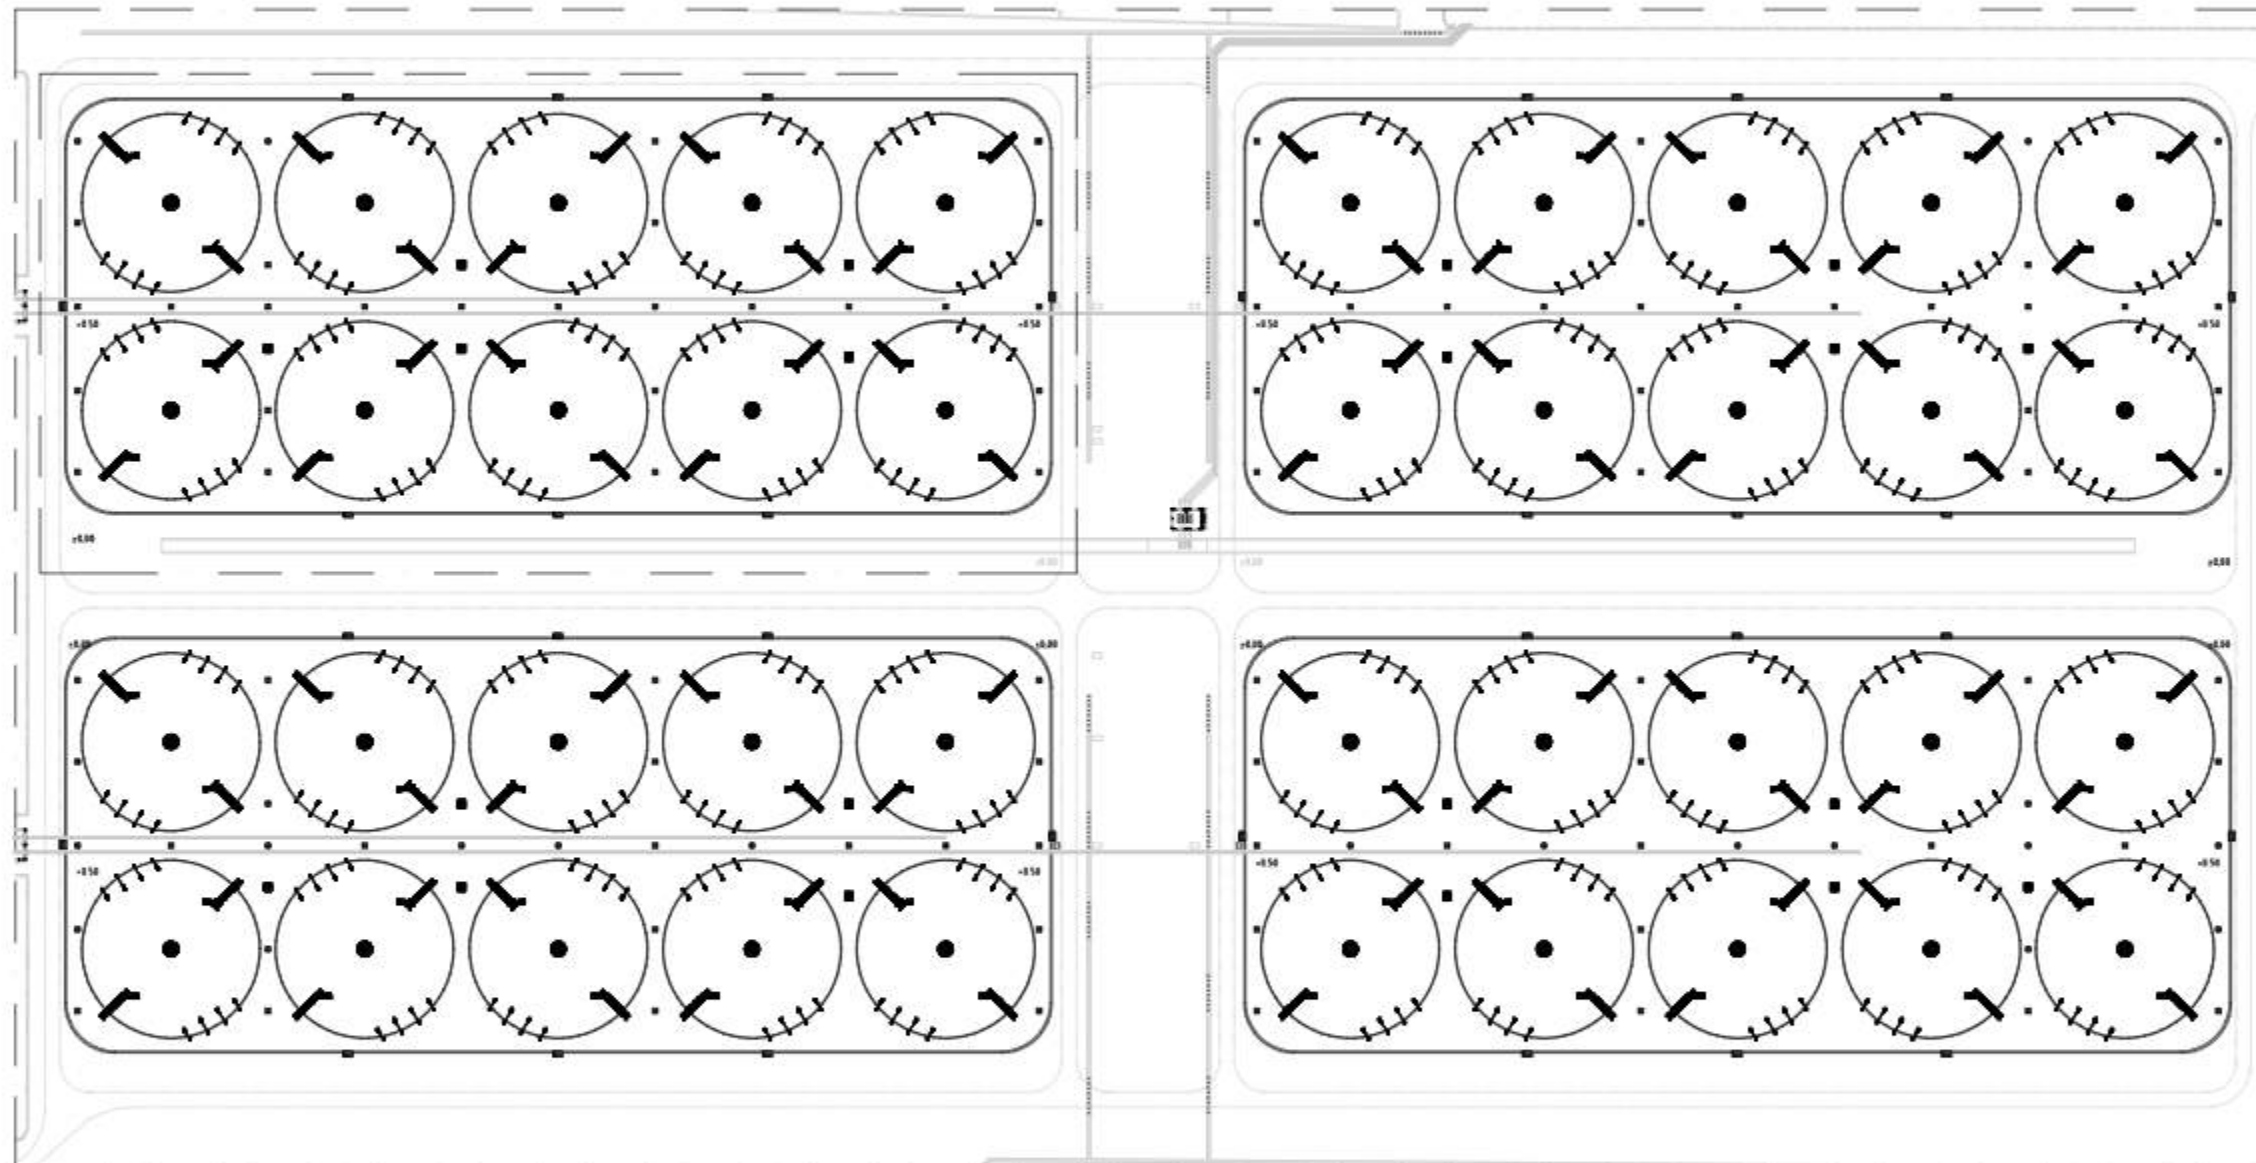

LAYOUT SITE PLAN KOLAM

SKALA 1 : 1.500



PEMBERI TUGAS



KEMENTERIAN KELAUTAN DAN PERIKANAN
DIREKTORAT JENDERAL PERIKANAN BUDI DAYA
INFRASTRUCTURE IMPROVEMENT OF SHRIMP AQUACULTURE PROJECT (ISAP)
JALAN MEDAN MERDEKA TRAJUR NOMOR 16
JAKARTA 10110 KOTAK POS 4190 JKP 10041
TELEPON (021) 2518079-112222, FAKS (021) 2514772
LAMARAN www.kkp.go.id SUREL id@kpp.go.id

PEKERJAAN

GAMBAR DETAIL ENGINEERING DESIGN (DED)
TAMBAK UPT

LOKASI

DESA DATA, KEC. DUAM PANUA
KAB. PINRANG, PROV. SULAWESI SELATAN

REVISI

NO	TGL	LOKASI	GMBR	DICEK	DISETUJUI

KONSULTAN PERENCANA



PT. DUTA CIPTA MANDIRI ENGINEERING CONSULTANT

AND IN SUB CONSULTANCY WITH



PT. SUCOFINDO ADVISORY UTAMA



PT. INAME UTAMA



PT. CAKRA BUANA AGHNA

DISUSUN :


Dr. Ir. BAMBANG SUMARTONO, M.Sc.
Aquaculture Specialist (Team Leader) [AQSTL]

DISETUJUI :

PEJABAT PEMBUAT KOMITMEN
INFRASTRUCTURE IMPROVEMENT OF SHRIMP AQUACULTURE PROJECT

SOLEHUDIN ABDUL GANI, S.P.
NIP. 19700727 200112 1 001

JUDUL GAMBAR		SKALA
LAYOUT SITE PLAN KOLAM		1 : 1.500
KODE GAMBAR	HAL GAMBAR	TAHUN
LDK-03.01	-	2024

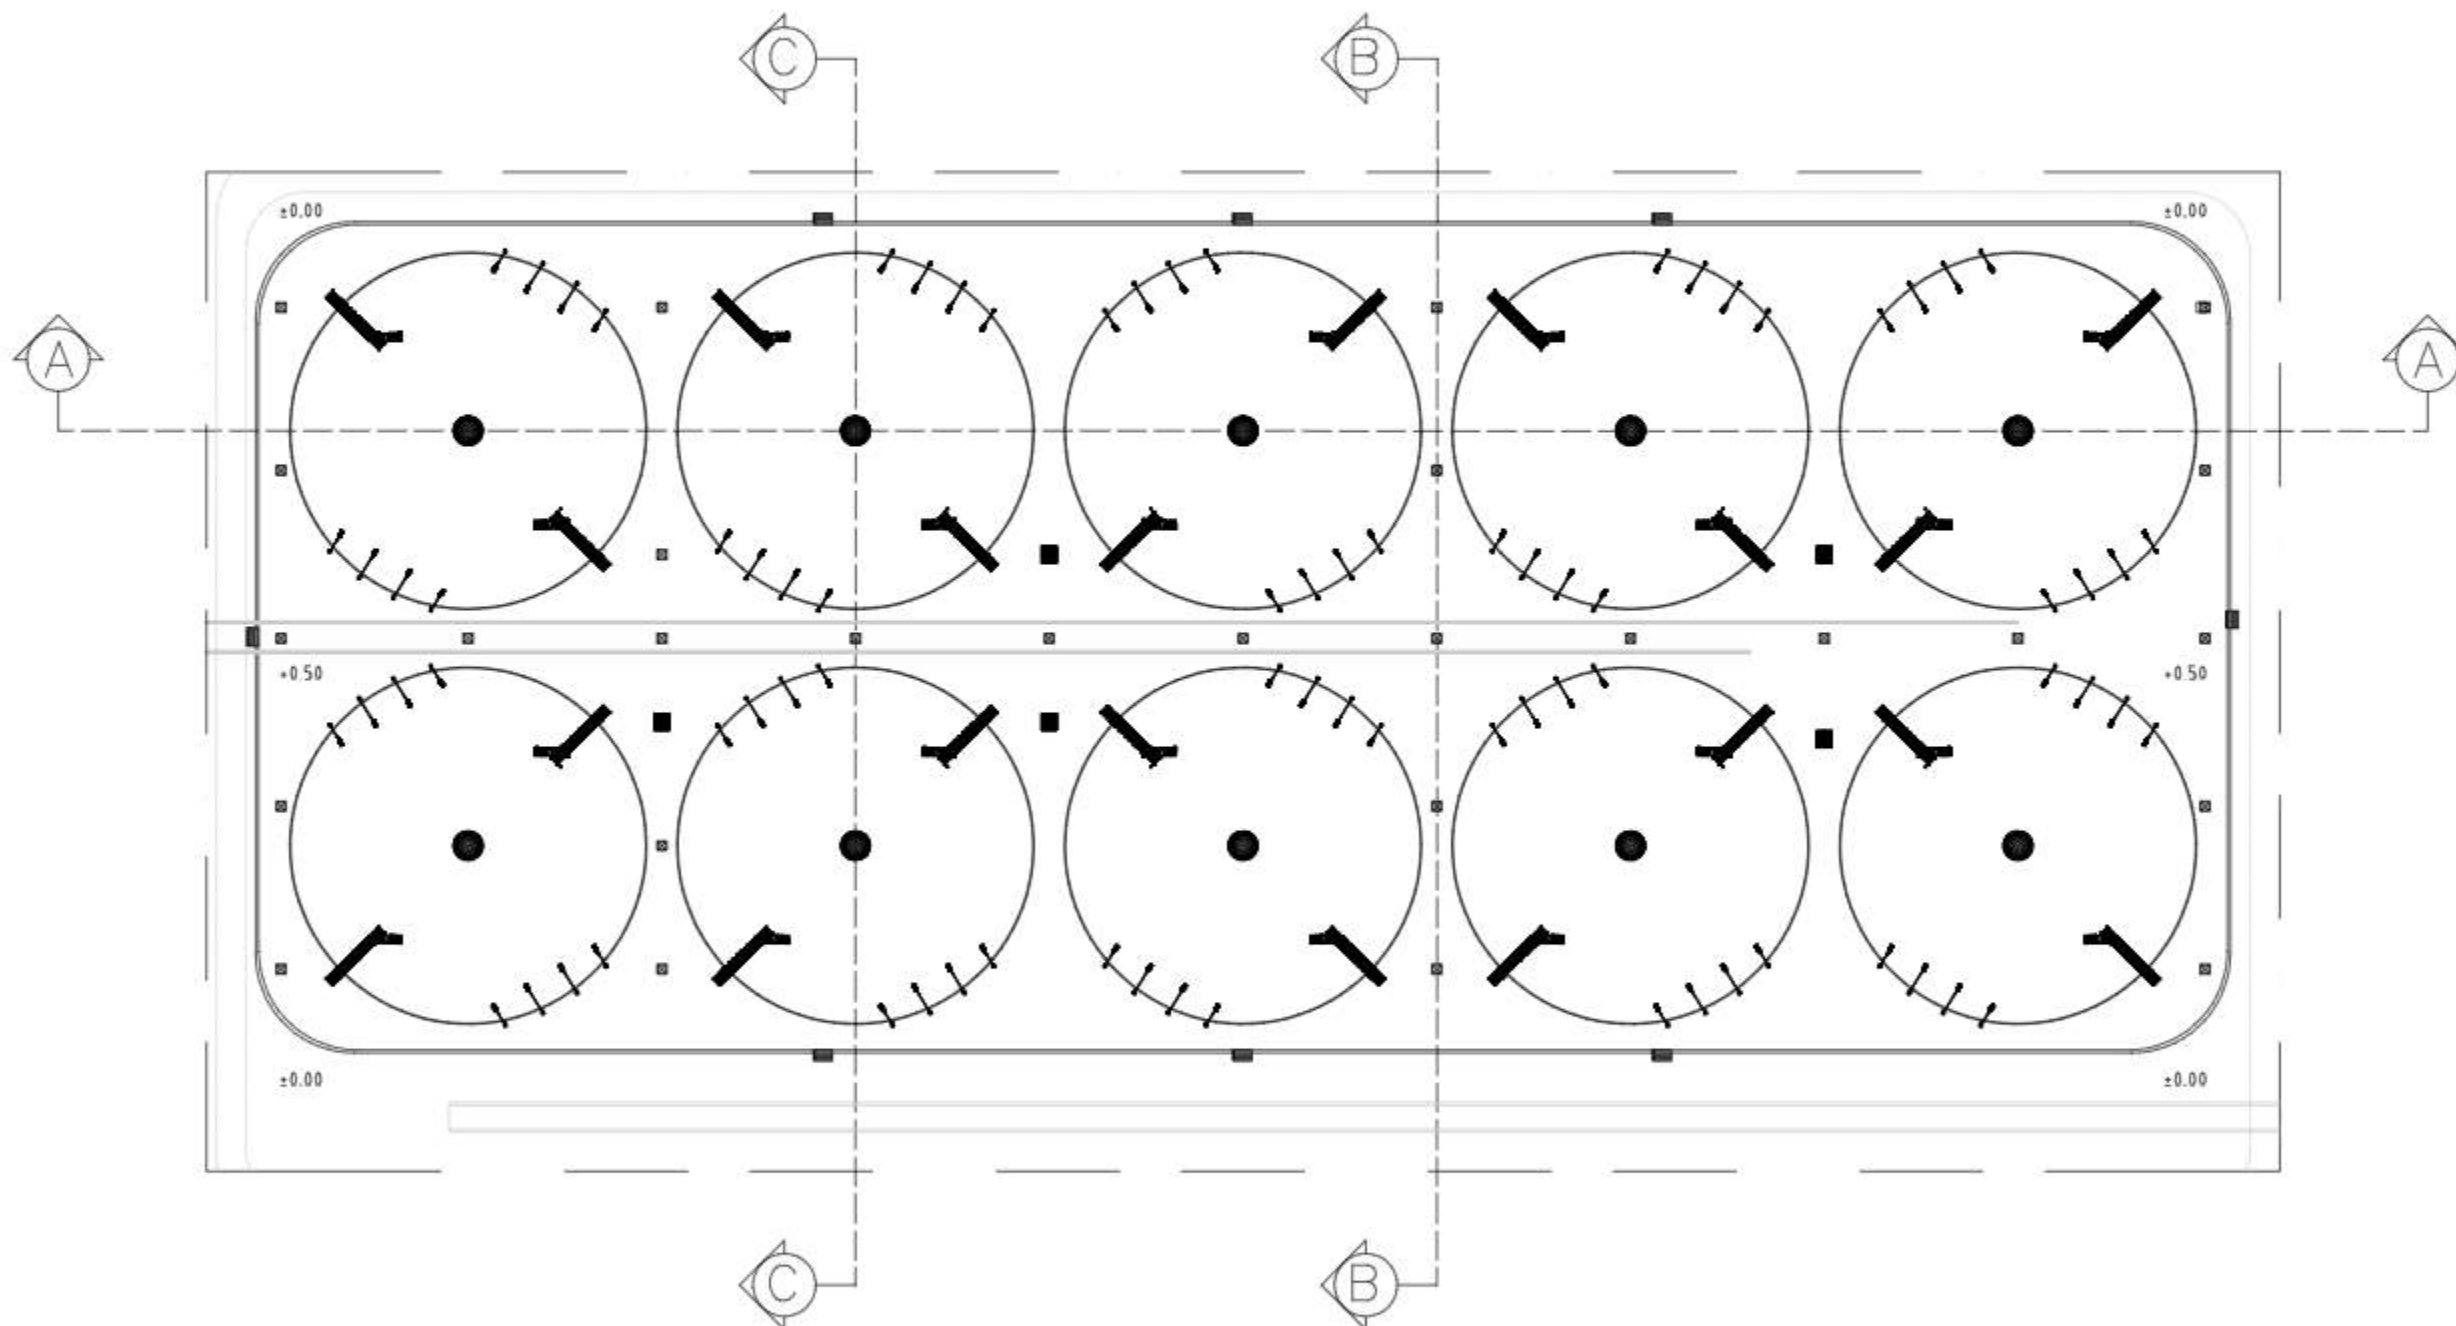

DETAIL LAYOUT MODUL KOLAM

SKALA 1 : 750



PEMBERI TUGAS



KEMENTERIAN KELAUTAN DAN PERIKANAN
DIREKTORAT JENDERAL PERIKANAN BUDI DAYA
INFRASTRUCTURE IMPROVEMENT OF SHRIMP AQUACULTURE PROJECT (ISAP)
JALAN MEDAN MERDEKA TIMUR NOMOR 16
JAKARTA 10110 KOTAK POS 4130 JKP 10041
TELEPON (021) 3019070-8 ACARA, FAKS/TELEPON (021) 3014772
LAMARAN www.kemari.go.id SUREL @kemari.go.id

PEKERJAAN

GAMBAR DETAIL ENGINEERING DESIGN (DED)
TAMBAK UPT

LOKASI

DESA DATA, KEC. DUAM PANUA
KAB. PINRANG, PROV. SULAWESI SELATAN

REVISI

NO	TGL	LOKASI	GMBR	DICEK	DISETUJUI

KONSULTAN PERENCANA



PT. DUTA CIPTA MANDIRI ENGINEERING CONSULTANT

AND IN SUB CONSULTANCY WITH



PT. SUCOFINDO ADVISORY UTAMA



PT. INAME UTAMA



PT. CAKRA BUANA AGHNA

DISUSUN :

Dr. Ir. BAMBANG SUMARTONO, M.Sc.
Aquaculture Specialist (Team Leader) [AQ&TL]

DISETUJUI :


PEJABAT PEMBUAT KOMITMEN
INFRASTRUCTURE IMPROVEMENT OF SHRIMP AQUACULTURE PROJECT

SOLEHUDIN ABDUL GANI S.PI
NIP. 19700727 200112 1 001

JUDUL GAMBAR		SKALA
DETAIL LAYOUT MODUL KOLAM		1 : 750
KODE GAMBAR	HAL. GAMBAR	TAHUN
LDK-02.02	-	2024



POTONGAN A - A
SKALA 1 : 650

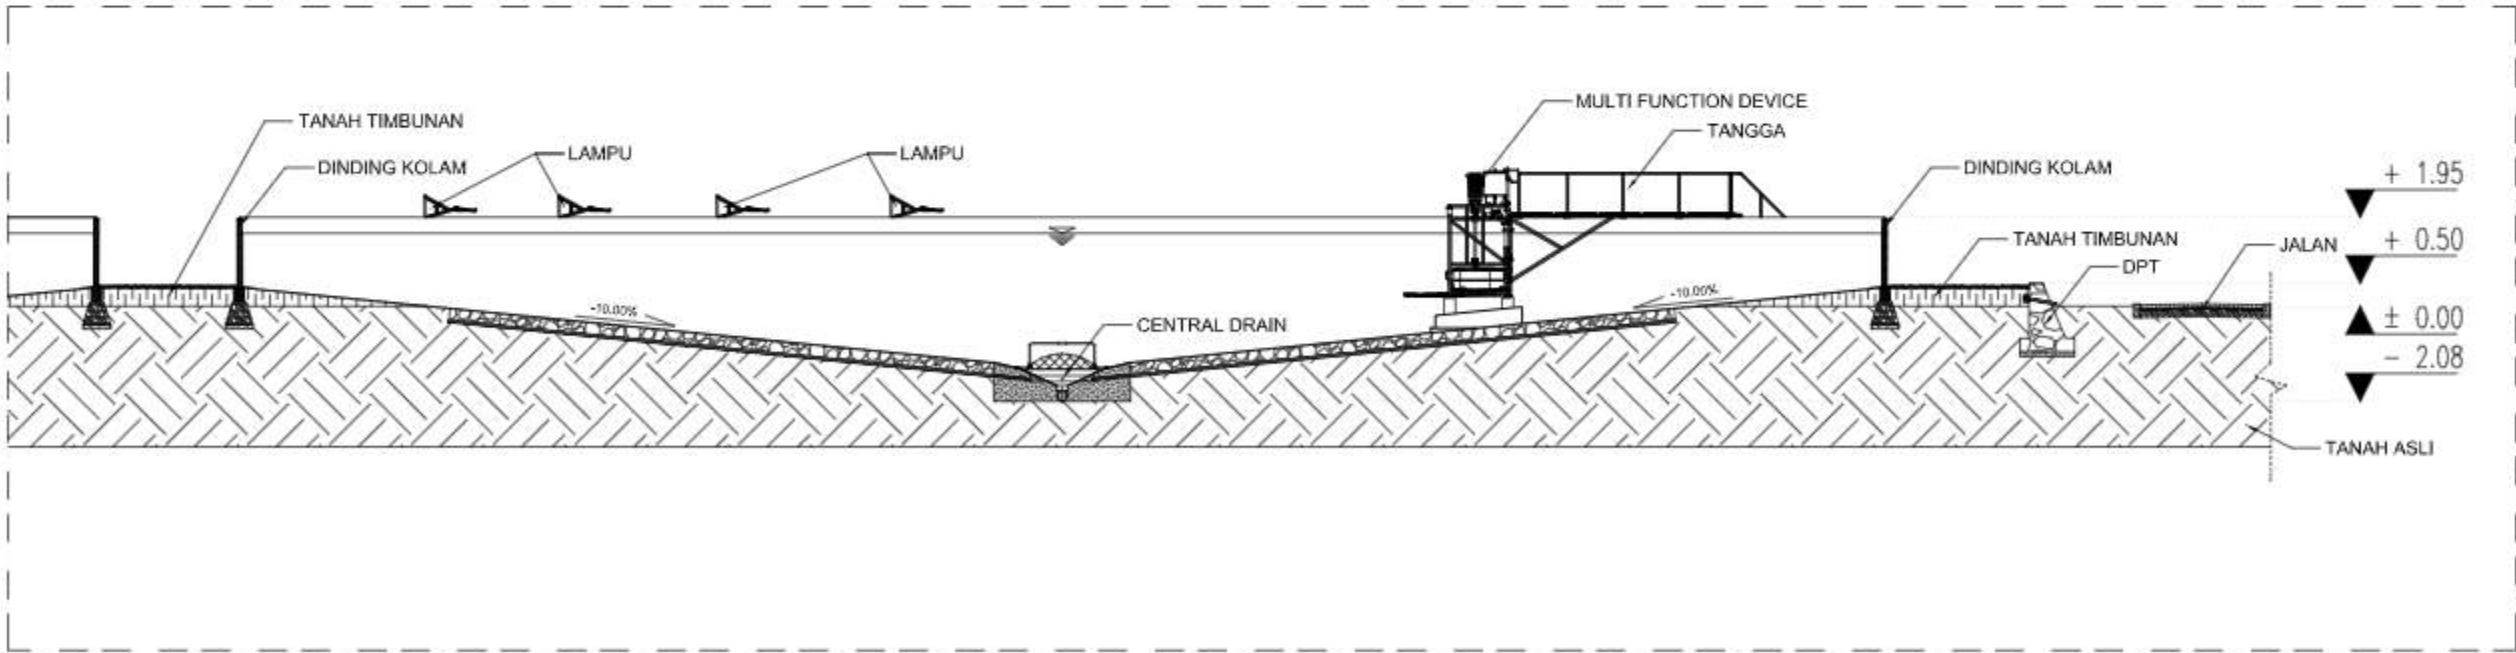

D.1 POTONGAN A - A
SKALA 1 : 25

PEMBERI TUGAS



KEMENTERIAN KELAUTAN DAN PERIKANAN
DIREKTORAT JENDERAL PERIKANAN BUDI DAYA
INFRASTRUCTURE IMPROVEMENT OF SHRIMP AQUACULTURE PROJECT (ISAP)
JALAN MEDAN MERDEKA TIMUR NOMOR 16
JAKARTA 10110 KOTAK POS 4130 JKP 10041
TELEPON (021) 3519070-8 ACARA, FAKS/TELE (021) 3514772
LAMARAN www.kkp.go.id SUREL @kpp.go.id

PEKERJAAN

GAMBAR DETAIL ENGINEERING DESIGN (DED)
TAMBAK UPT

LOKASI

DESA DATA, KEC. DUAM PANUA
KAB. PINRANG, PROV. SULAWESI SELATAN

REVISI

NO	TGL	LOKASI	GMBR	DICEK	DISETUIJI

KONSULTAN PERENCANA



PT. DUTA CIPTA MANDIRI ENGINEERING CONSULTANT
AND IN SUB CONSULTANCY WITH



PT. SUCOFINDO ADVISORY UTAMA



PT. INAME UTAMA



PT. CAKRA BUANA AGHNA

DISUSUN :

Dr. Ir. BAMBANG SUMARTONO, M.Sc.
Aquaculture Specialist (Team Leader) [AQ&TL]

DISETUIJI :

PEJABAT PEMBUAT KOMITMEN
INFRASTRUCTURE IMPROVEMENT OF SHRIMP AQUACULTURE PROJECT

SOLEHUDIN ABDUL GANI S.P.
NIP. 19700727 200112 1 001

JUDUL GAMBAR

SKALA

POTONGAN A - A
DAN DETAIL POTONGAN D.1

1 : 650

KODE GAMBAR


HAL GAMBAR

TAHUN

LDK-04.02


-

2024

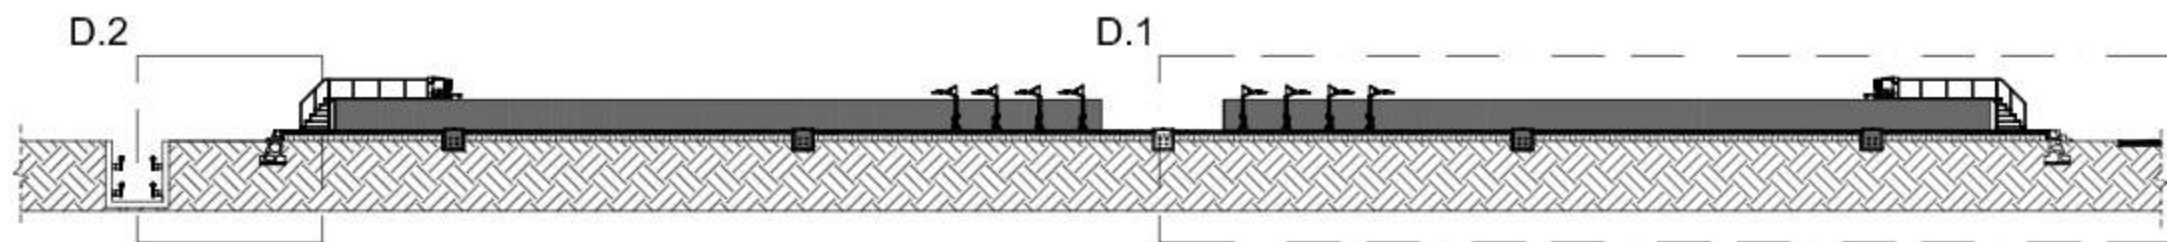


POTONGAN B - B

SKALA 1 : 350

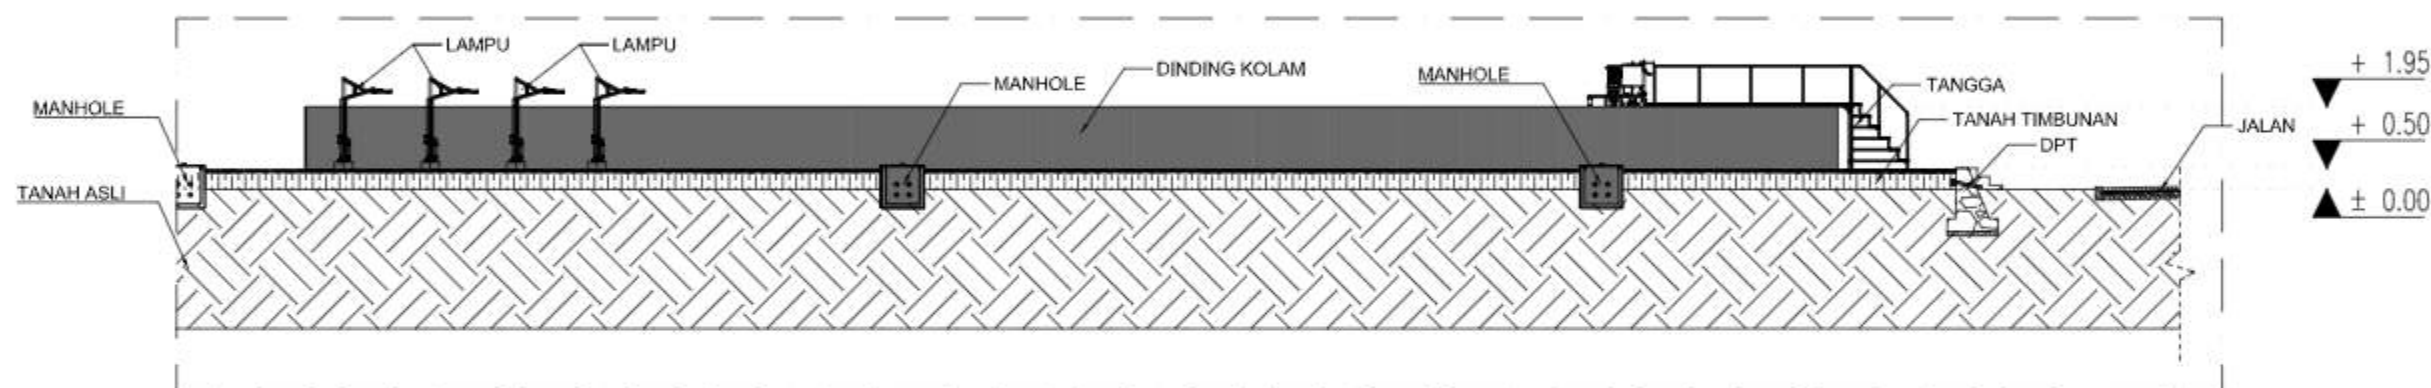

D.1 POTONGAN B - B

SKALA 1 : 50

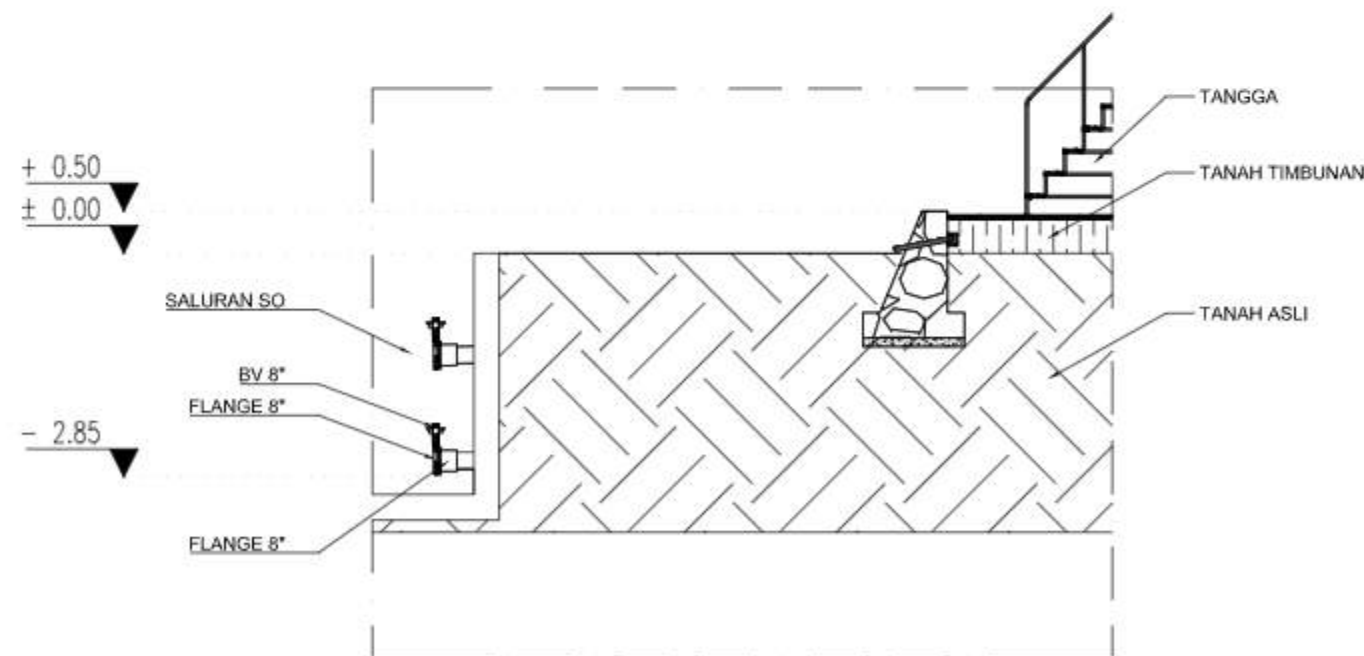

D.2 POTONGAN B - B

SKALA 1 : 25



PEMBERI TUGAS



KEMENTERIAN KELAUTAN DAN PERIKANAN
DIREKTORAT JENDERAL PERIKANAN BUDI DAYA
INFRASTRUCTURE IMPROVEMENT OF SHRIMP AQUACULTURE PROJECT (ISAP)
JALAN MEDAN MERDEKA TIMUR NOMOR 16
JAKARTA 10110 KOTAK POS 4130 JKT 10041
TELEPON (021) 3019070-8 ACARA, PANGSALEP 10211 3516772
LAMAN www.kkp.go.id SUREL @kpp.go.id

PEKERJAAN

GAMBAR DETAIL ENGINEERING DESIGN (DED)
TAMBAK UPT

LOKASI

DESA DATA, KEC. DUAM PANUA
KAB. PINRANG, PROV. SULAWESI SELATAN

REVISI

NO	TGL	LOKASI	GMBR	DICEK	DISETUJUI

KONSULTAN PERENCANA



PT. DUTA CIPTA MANDIRI ENGINEERING CONSULTANT

AND IN SUB CONSULTANCY WITH



PT. SUCOFINDO ADVISORY UTAMA



PT. INAME UTAMA



PT. CAKRA BUANA AGHNA

DISUSUN :

[Signature]

Dr. Ir. BAMBANG SUMARTONO, M.Sc.
Aquaculture Specialist (Team Leader) [AQ&TL]


DISETUJUI :

PEJABAT PEMBUAT KOMITMEN
INFRASTRUCTURE IMPROVEMENT OF SHRIMP AQUACULTURE PROJECT

[Signature]


SOLEHUDIN ABDUL GANI, S.Pi
NIP. 19700727 200112 1 001

JUDUL GAMBAR		SKALA
POTONGAN B - B, DETAIL POTONGAN D.1 & D.2		1 : 350 1 : 50 1 : 25
KODE GAMBAR	HAL GAMBAR	TAHUN
LDK-04.03	-	2024

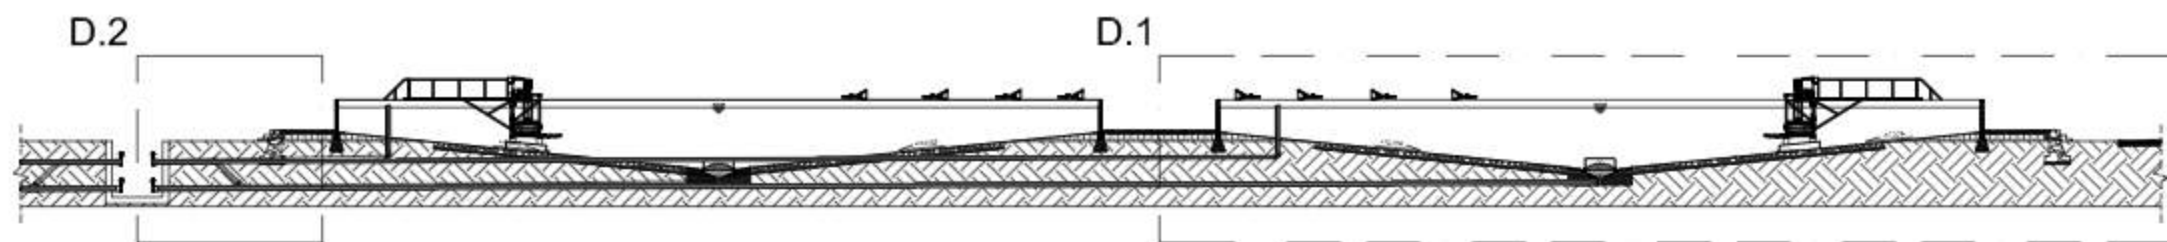


POTONGAN C - C

SKALA 1 : 350

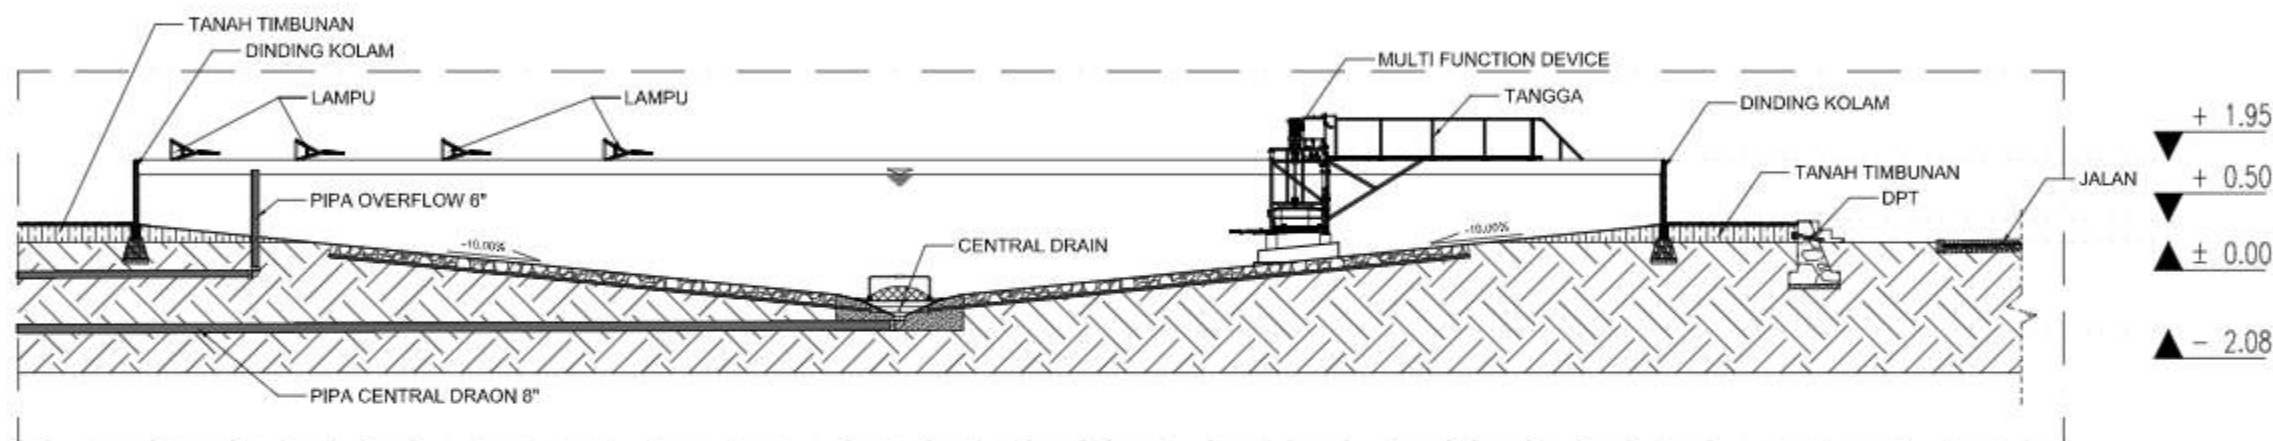

D.1 POTONGAN C - C

SKALA 1 : 50

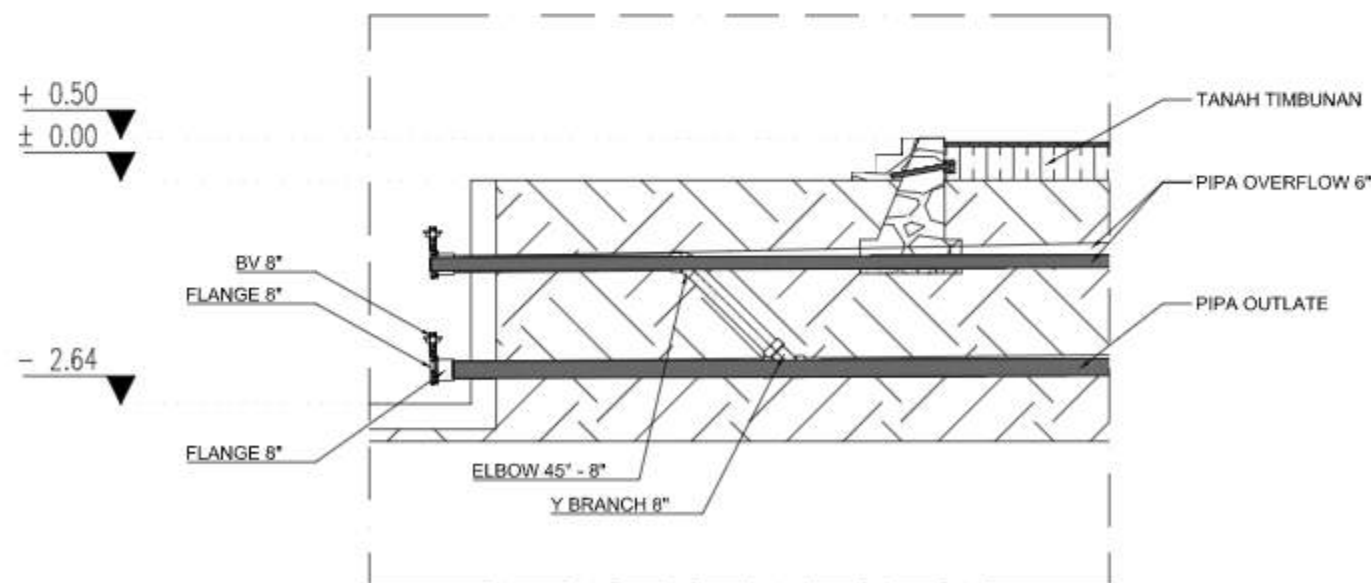

D.2 POTONGAN C - C

SKALA 1 : 25

PEMBERI TUGAS



KEMENTERIAN KELAUTAN DAN PERIKANAN
DIREKTORAT JENDERAL PERIKANAN BUDI DAYA
INFRASTRUCTURE IMPROVEMENT OF SHRIMP AQUACULTURE PROJECT (ISAP)
JALAN MEDAN MERDEKA TIMUR NOMOR 16
JAKARTA 10110 KOTAK POS 4130 JKP 10041
TELEPON (021) 3519070-8 ACARA, PANGSABE 10211 3516772
LAMARAN www.kkp.go.id SUREL @kpp@kp.go.id

PEKERJAAN

GAMBAR DETAIL ENGINEERING DESIGN (DED)
TAMBAK UPT

LOKASI

DESA DATA, KEC. DUAM PANUA
KAB. PINRANG, PROV. SULAWESI SELATAN

REVISI

NO	TGL	LOKASI	GMBR	DICEK	DISETUJUI

KONSULTAN PERENCANA

- PT. DUTA CIPTA MANDIRI ENGINEERING CONSULTANT
AND IN SUB CONSULTANCY WITH
PT. SUCOFINDO ADVISORY UTAMA
PT. INAME UTAMA
PT. CAKRA BUANA AGHNA

DISUSUN :

[Signature]

Dr. Ir. BAMBANG SUMARTONO, M.Sc.
Aquaculture Specialist (Team Leader) [AQ&TL]


DISETUJUI :

PEJABAT PEMBUAT KOMITMEN
INFRASTRUCTURE IMPROVEMENT OF SHRIMP AQUACULTURE PROJECT

[Signature]

SOLEHUDIN ABDUL GANI, S.Pi
NIP. 19700727 200112 1 001

JUDUL GAMBAR		SKALA
POTONGAN C - C, DETAIL POTONGAN D.1 & D.2		1 : 350 1 : 50 1 : 25
KODE GAMBAR	HAL GAMBAR	TAHUN
LDK-04.04	-	2024

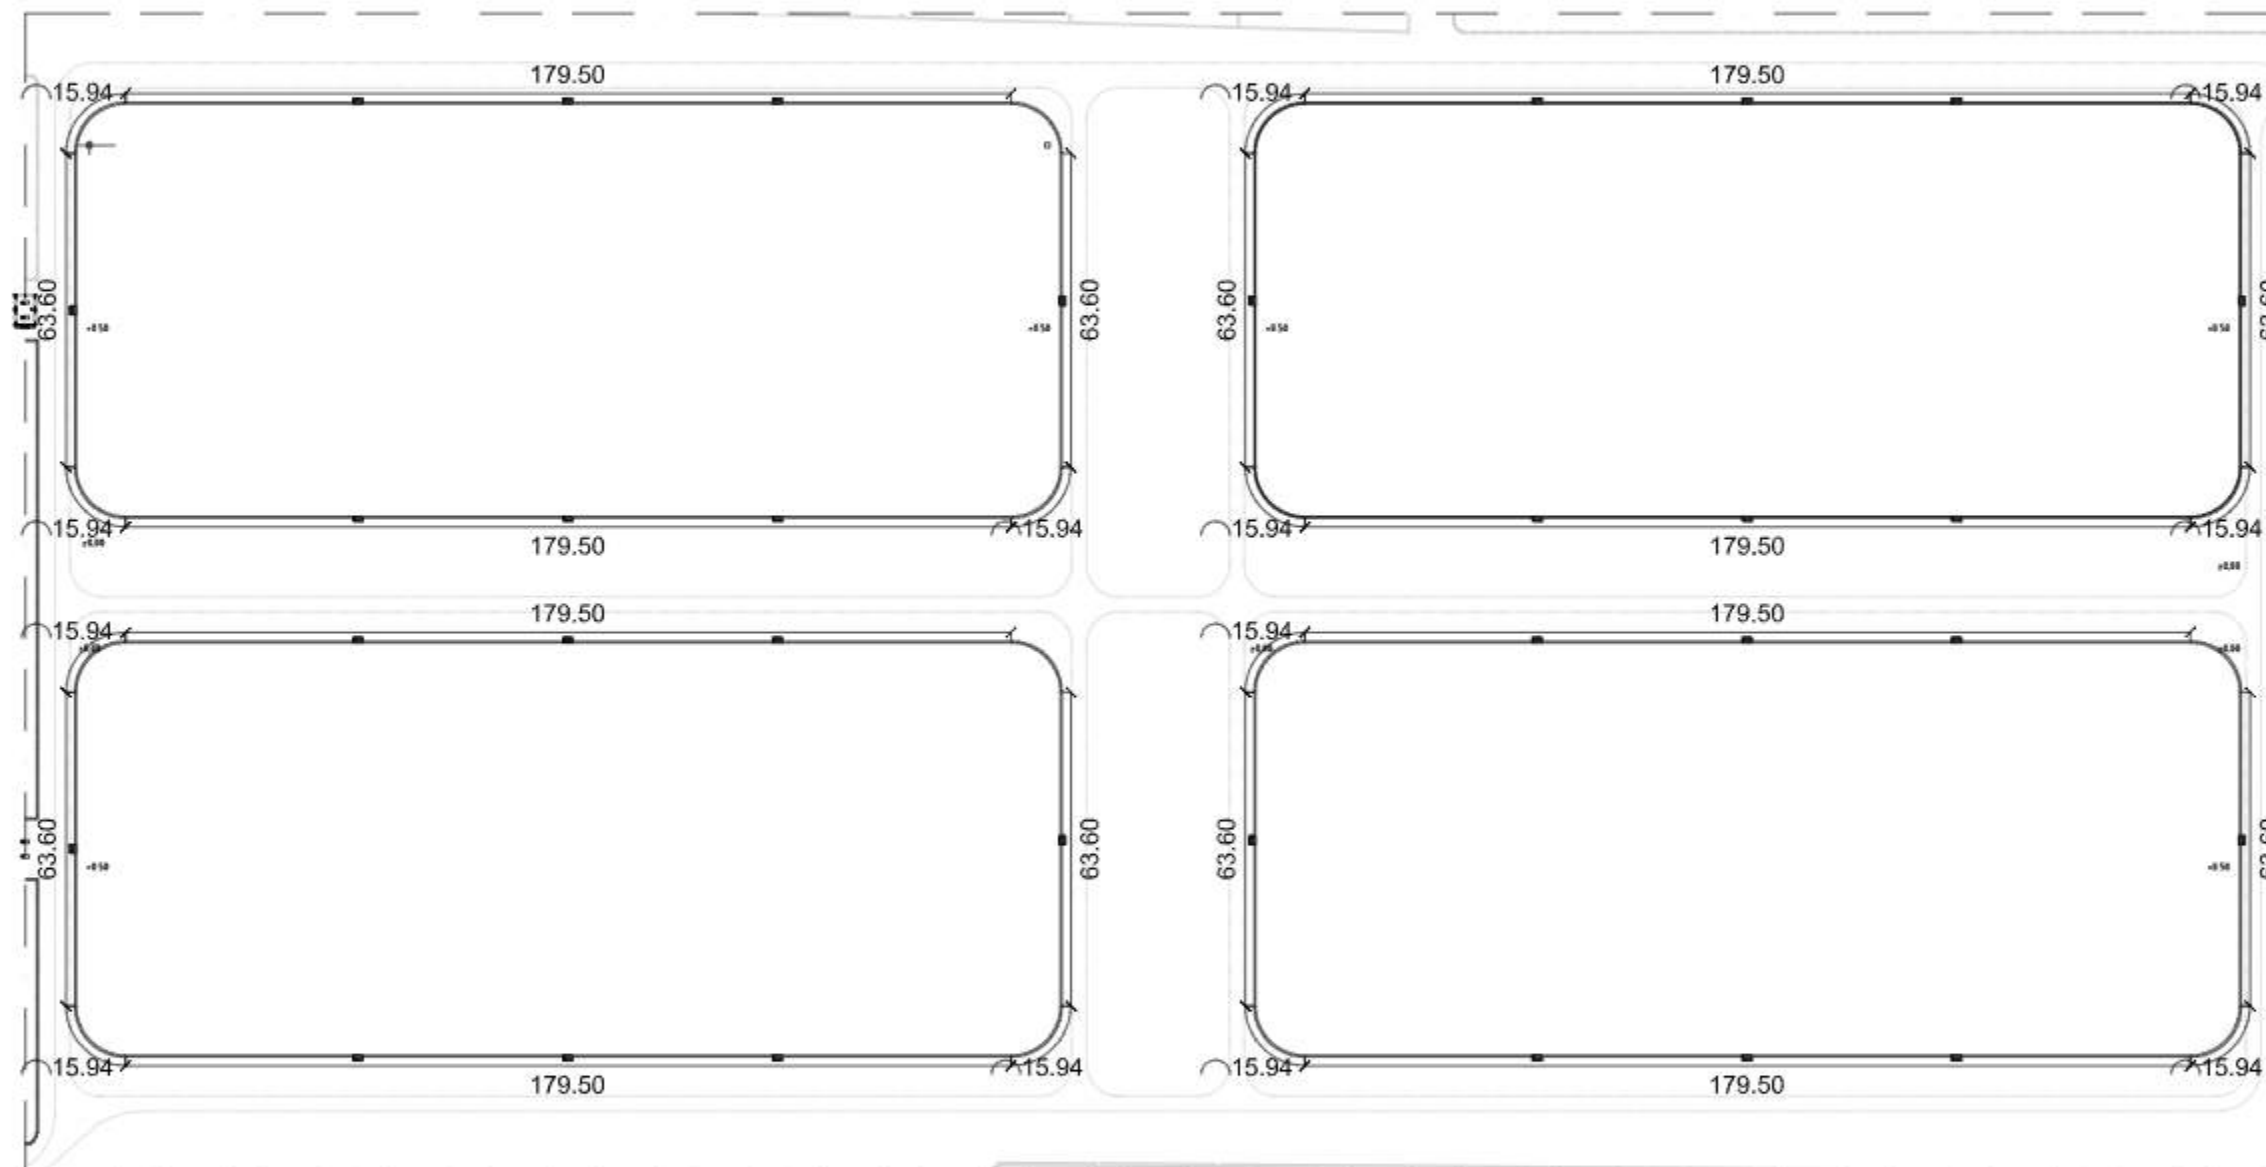

LAYOUT DPT
SKALA 1 : 1.500



PEMBERI TUGAS



KEMENTERIAN KELAUTAN DAN PERIKANAN
DIREKTORAT JENDERAL PERIKANAN BUDI DAYA
INFRASTRUCTURE IMPROVEMENT OF SHRIMP AQUACULTURE PROJECT (ISAP)
JALAN MEDAN MERDEKA TRAJUR NOMOR 16
JAKARTA 10110 KOTAK POS 4190 JKP 10041
TELEPON (021) 2518779 ILACAK, PANGSABELE (021) 2514772
LAMAN www.kkp.go.id SUREL id@kpp.go.id

PEKERJAAN

GAMBAR DETAIL ENGINEERING DESIGN (DED)
TAMBAK UPT

LOKASI

DESA DATA, KEC. DUAM PANUA
KAB. PINRANG, PROV. SULAWESI SELATAN

REVISI

NO	TGL	LOKASI	GMBR	DICEK	DISETUJUI

KONSULTAN PERENCANA

- PT. DUTA Cipta Mandiri Engineering Consultant
AND IN SUB CONSULTANCY WITH
PT. SUCOFINDO ADVISORY UTAMA
PT. INAME UTAMA
PT. CAKRA BUANA AGHNA

DISUSUN :


Dr. Ir. BAMBANG SUMARTONO, M.Sc.
Aquaculture Specialist (Team Leader) [AQSTL]

DISETUJUI :

PEJABAT PEMBUAT KOMITMEN
INFRASTRUCTURE IMPROVEMENT OF SHRIMP AQUACULTURE PROJECT

SOLEHUDIN ABDUL GANI, S.P.
NIP. 19700727 200112 1 001


JUDUL GAMBAR		SKALA
LAYOUT DPT KOLAM		1 : 1.500
KODE GAMBAR	HAL GAMBAR	TAHUN
LDK-05.01	-	2024

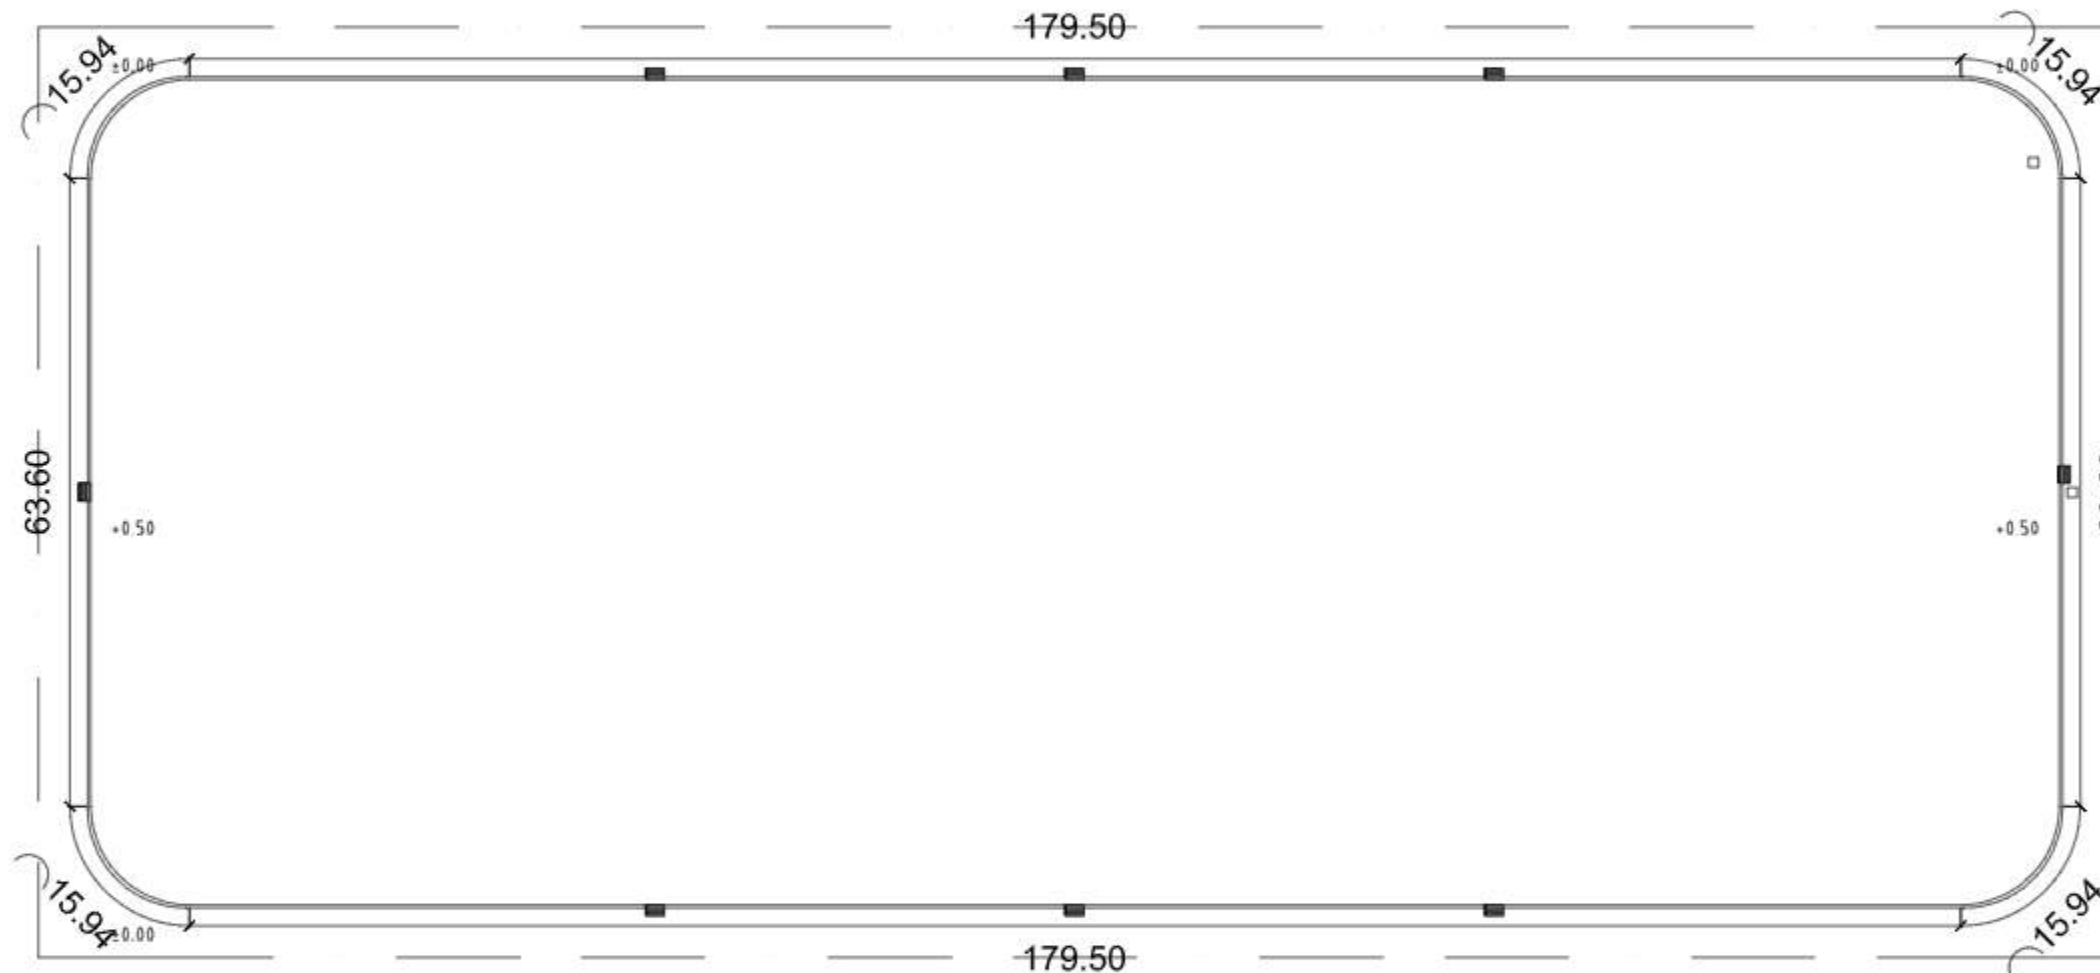

DETAIL LAYOUT MODUL DPT
SKALA 1 : 750




PEMBERI TUGAS					
 KEMENTERIAN KELAUTAN DAN PERIKANAN DIREKTORAT JENDERAL PERIKANAN BUDI DAYA INFRASTRUCTURE IMPROVEMENT OF SHRIMP AQUACULTURE PROJECT (ISAP) JALAN MEDAN MERDEKA TIMUR NOMOR 16 JAKARTA 10110 KOTAK POS 4130 JKP 10041 TELEPON (021) 3019070-8 ACARA, PANGKALAN 10211 3516772 LAMAN www.kkp.go.id SUREL @kpp@kp.go.id					
PEKERJAAN					
GAMBAR DETAIL ENGINEERING DESIGN (DED) TAMBAK UPT					
LOKASI					
DESA DATA, KEC. DUAM PANUA KAB. PINRANG, PROV. SULAWESI SELATAN					
REVISI					
NO	TGL	LOKASI	GMBR	DICEK	DISETUJUI
KONSULTAN PERENCANA					
 PT. DUTA CIPTA MANDIRI ENGINEERING CONSULTANT AND IN SUB CONSULTANCY WITH  PT. SUCOFINDO ADVISORY UTAMA  PT. INAME UTAMA  PT. CAKRA BUANA AGHNA					
DISUSUN :					
 Dr. Ir. BAMBANG SUMARTONO, M.Sc. Aquaculture Specialist (Team Leader) [AQ&TL]					
DISETUJUI :					
PEJABAT PEMBUAT KOMITMEN INFRASTRUCTURE IMPROVEMENT OF SHRIMP AQUACULTURE PROJECT  SOLEHUDIN ABDUL GANI, S.Pi NIP. 19700727 200112 1 001					
JUDUL GAMBAR			SKALA		
DETAIL LAYOUT MODUL DPT			1 : 750		
KODE GAMBAR	HAL GAMBAR	TAHUN			
LDK-06.01	-	2024			

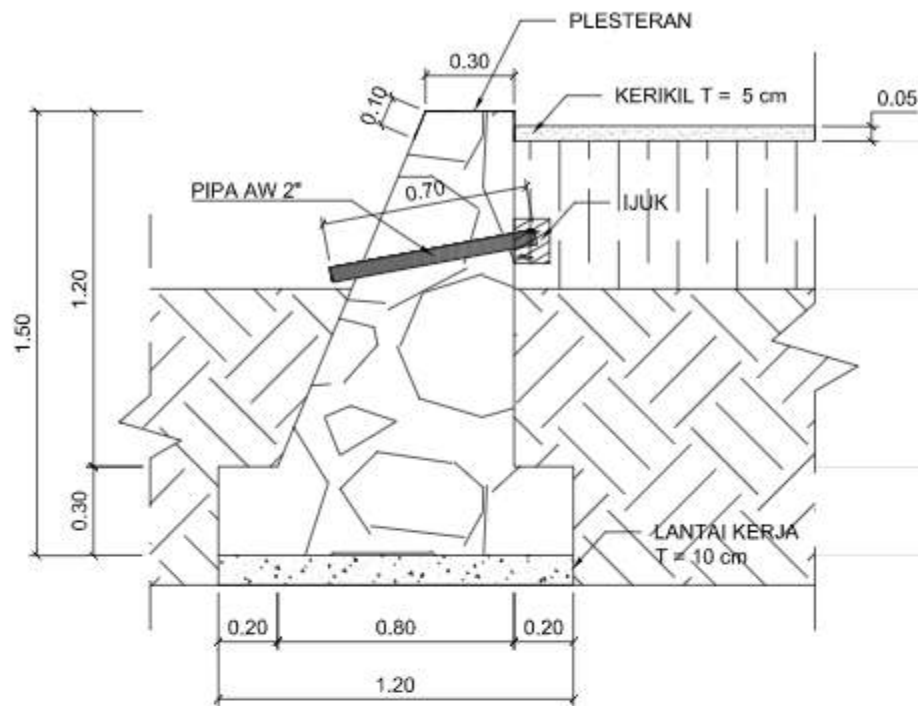


DETAIL DPT KOLAM

SKALA 1 : 25

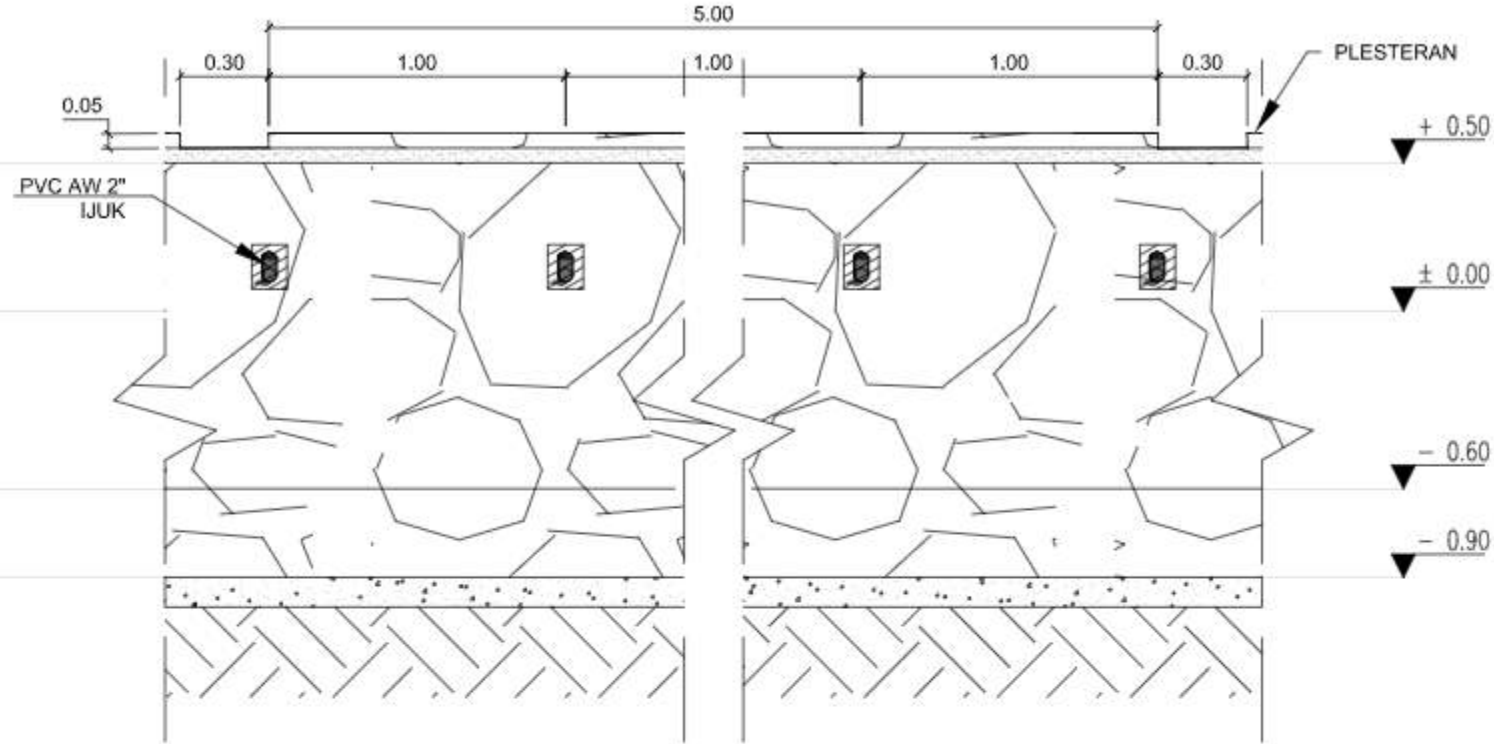


DETAIL PIPA DPT

SKALA 1 : 25

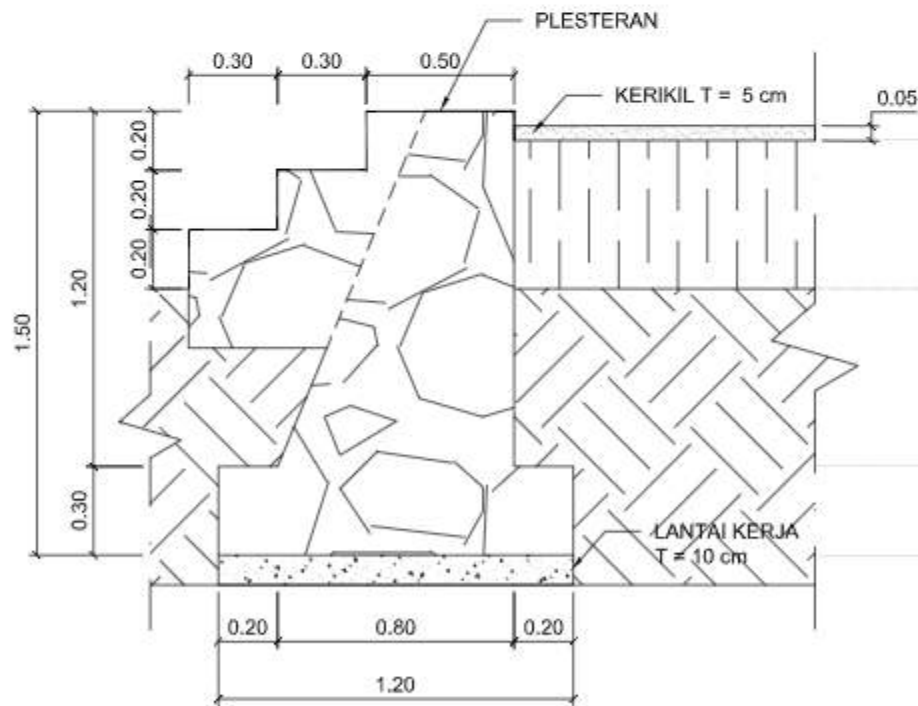

DETAIL DPT KOLAM

SKALA 1 : 25

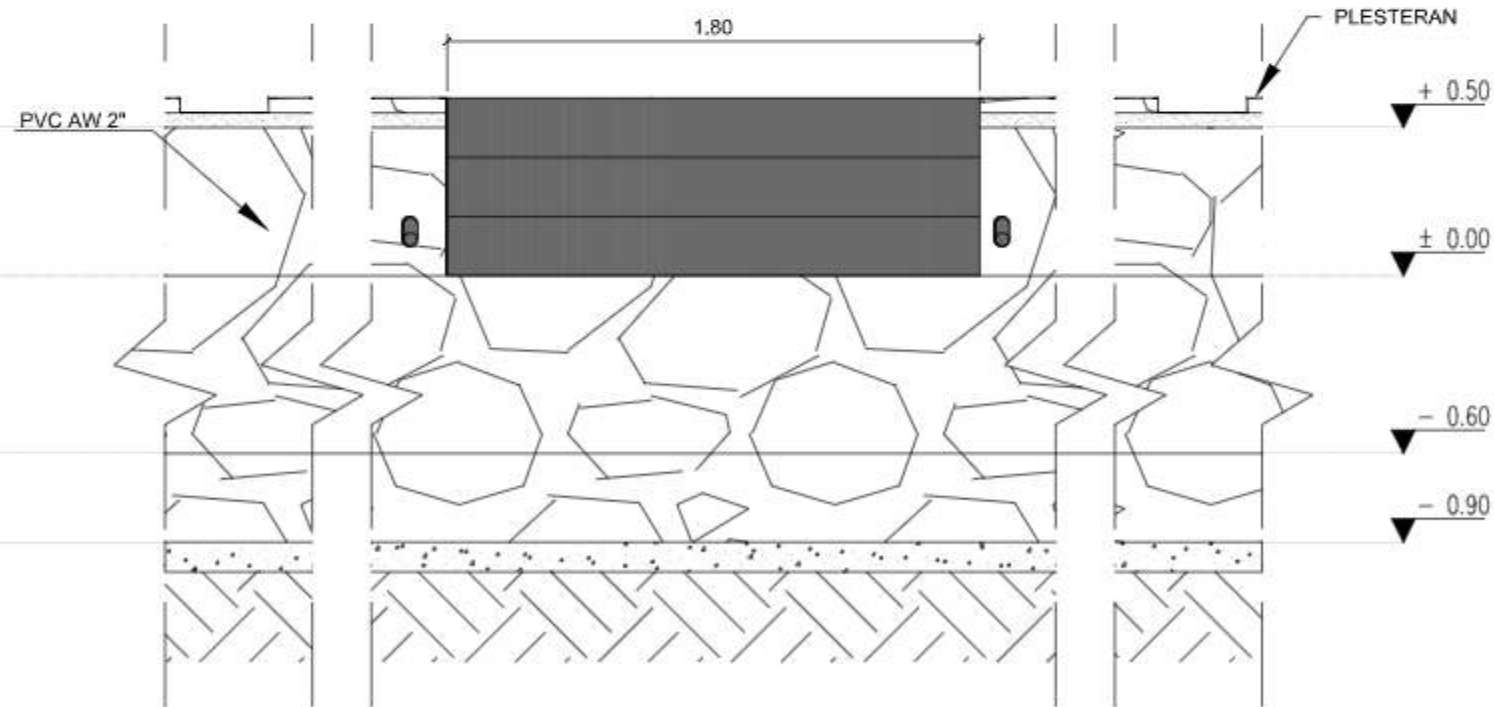

TAMPAK DEPAN TANGGA DPT

SKALA 1 : 25

PEMBERI TUGAS



KEMENTERIAN KELAUTAN DAN PERIKANAN
DIREKTORAT JENDERAL PERIKANAN BUDI DAYA
INFRASTRUCTURE IMPROVEMENT OF SHRIMP AQUACULTURE PROJECT (ISAP)
JALAN MEDAN MERDEKA TIMUR NOMOR 16
JAKARTA 10110 KOTAK POS 4150 JKP 10541
TELEPON (021) 3518079 (LACAK), FAKS (021) 3514772
LAMARAN www.kkp.go.id SUREL id@kpp.go.id

PEKERJAAN

GAMBAR DETAIL ENGINEERING DESIGN (DED)
TAMBAK UPT

LOKASI

DESA DATA, KEC. DUAM PANUA
KAB. PINRANG, PROV. SULAWESI SELATAN

REVISI

NO	TGL	LOKASI	GMBR	DICEK	DISETUJUI

KONSULTAN PERENCANA



PT. DUTA CIPTA MANDIRI ENGINEERING CONSULTANT

AND IN SUB CONSULTANCY WITH



PT. SUCOFINDO ADVISORY UTAMA



PT. INAME UTAMA



PT. CAKRA BUANA AGHNA

DISUSUN :

[Signature]

Dr. Ir. BAMBANG SUMARTONO, M.Sc.
Aquaculture Specialist (Team Leader) [AQSTL]


DISETUJUI :

PEJABAT PEMBUAT KOMITMEN
INFRASTRUCTURE IMPROVEMENT OF SHRIMP AQUACULTURE PROJECT

[Signature]

SOLEHUJUDIN ABDUL GANI, S.Pi
NIP. 19700727 200112 1 001

JUDUL GAMBAR		SKALA
DETAIL DPT		1 : 25
KODE GAMBAR	HAL GAMBAR	TAHUN
LDK-06.02	-	2024

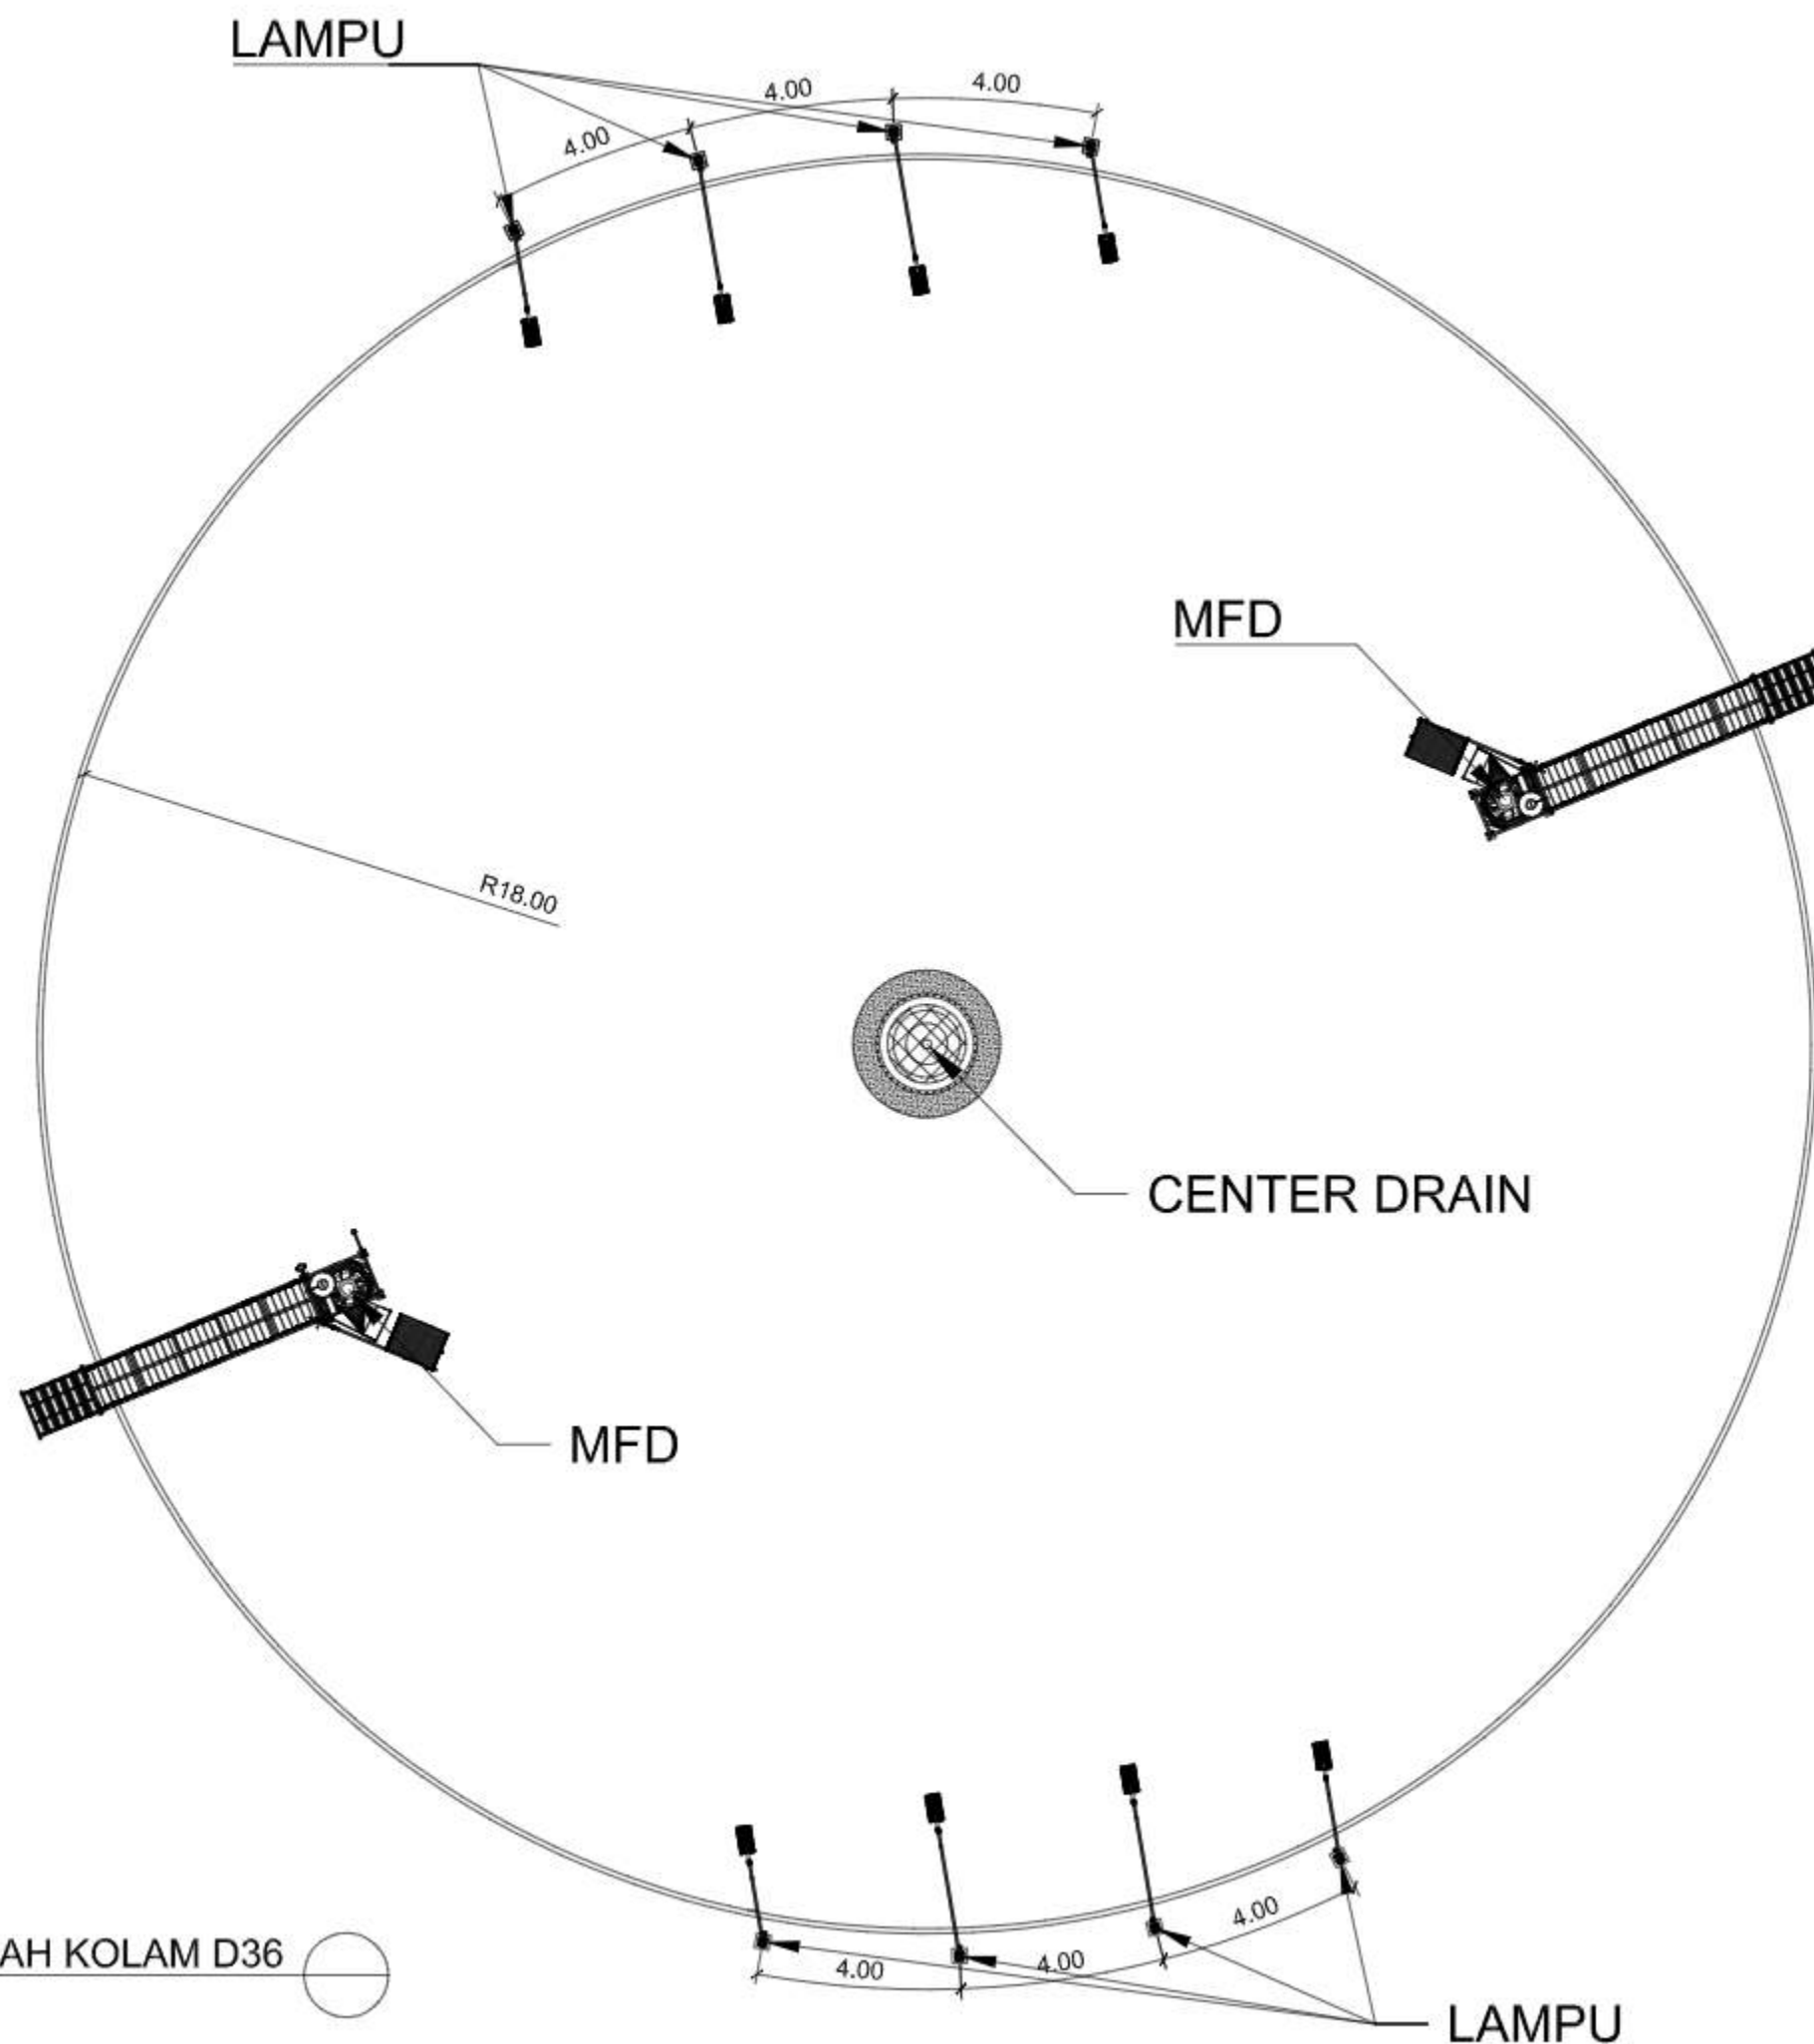

PEMBERI TUGAS



KEMENTERIAN KELAUTAN DAN PERIKANAN
DIREKTORAT JENDERAL PERIKANAN BUDI DAYA
INFRASTRUCTURE IMPROVEMENT OF SHRIMP AQUACULTURE PROJECT (ISAP)
JALAN MEDAN MERDEKA TRAJUR NOMER 16
JAKARTA 10110 KOTAK POS 4190 JKP 10041
TELEPON (021) 2518179 (LACAK), FAKS (021) 2514772
LAMPAK www.kkp.go.id SUREL id@kpp.go.id

PEKERJAAN

GAMBAR DETAIL ENGINEERING DESIGN (DED)
TAMBAK UPT

LOKASI

DESA DATA, KEC. DUAM PANUA
KAB. PINRANG, PROV. SULAWESI SELATAN

REVISI

NO	TGL	LOKASI	GMBR	DICEK	DISETUJUI

KONSULTAN PERENCANA



PT. DUTA CIPTA MANDIRI ENGINEERING CONSULTANT

AND IN SUB CONSULTANCY WITH



PT. SUCOFINDO ADVISORY UTAMA



PT. INAME UTAMA



PT. CAKRA BUANA AGHNA

DISUSUN :

Dr. Ir. BAMBANG SUMARTONO, M.Sc.
Aquaculture Specialist (Team Leader) [AQSTL]

DISETUJUI :

PEJABAT PEMBUAT KOMITMEN
INFRASTRUCTURE IMPROVEMENT OF SHRIMP AQUACULTURE PROJECT

SOLEHUDIN ABDUL GANI, S.P.
NIP. 19700727 200112 1 001

JUDUL GAMBAR

SKALA

DETAIL DENAH KOLAM D36

1 : 150

KODE GAMBAR


HAL GAMBAR

TAHUN

LDK-07.01

-

2024

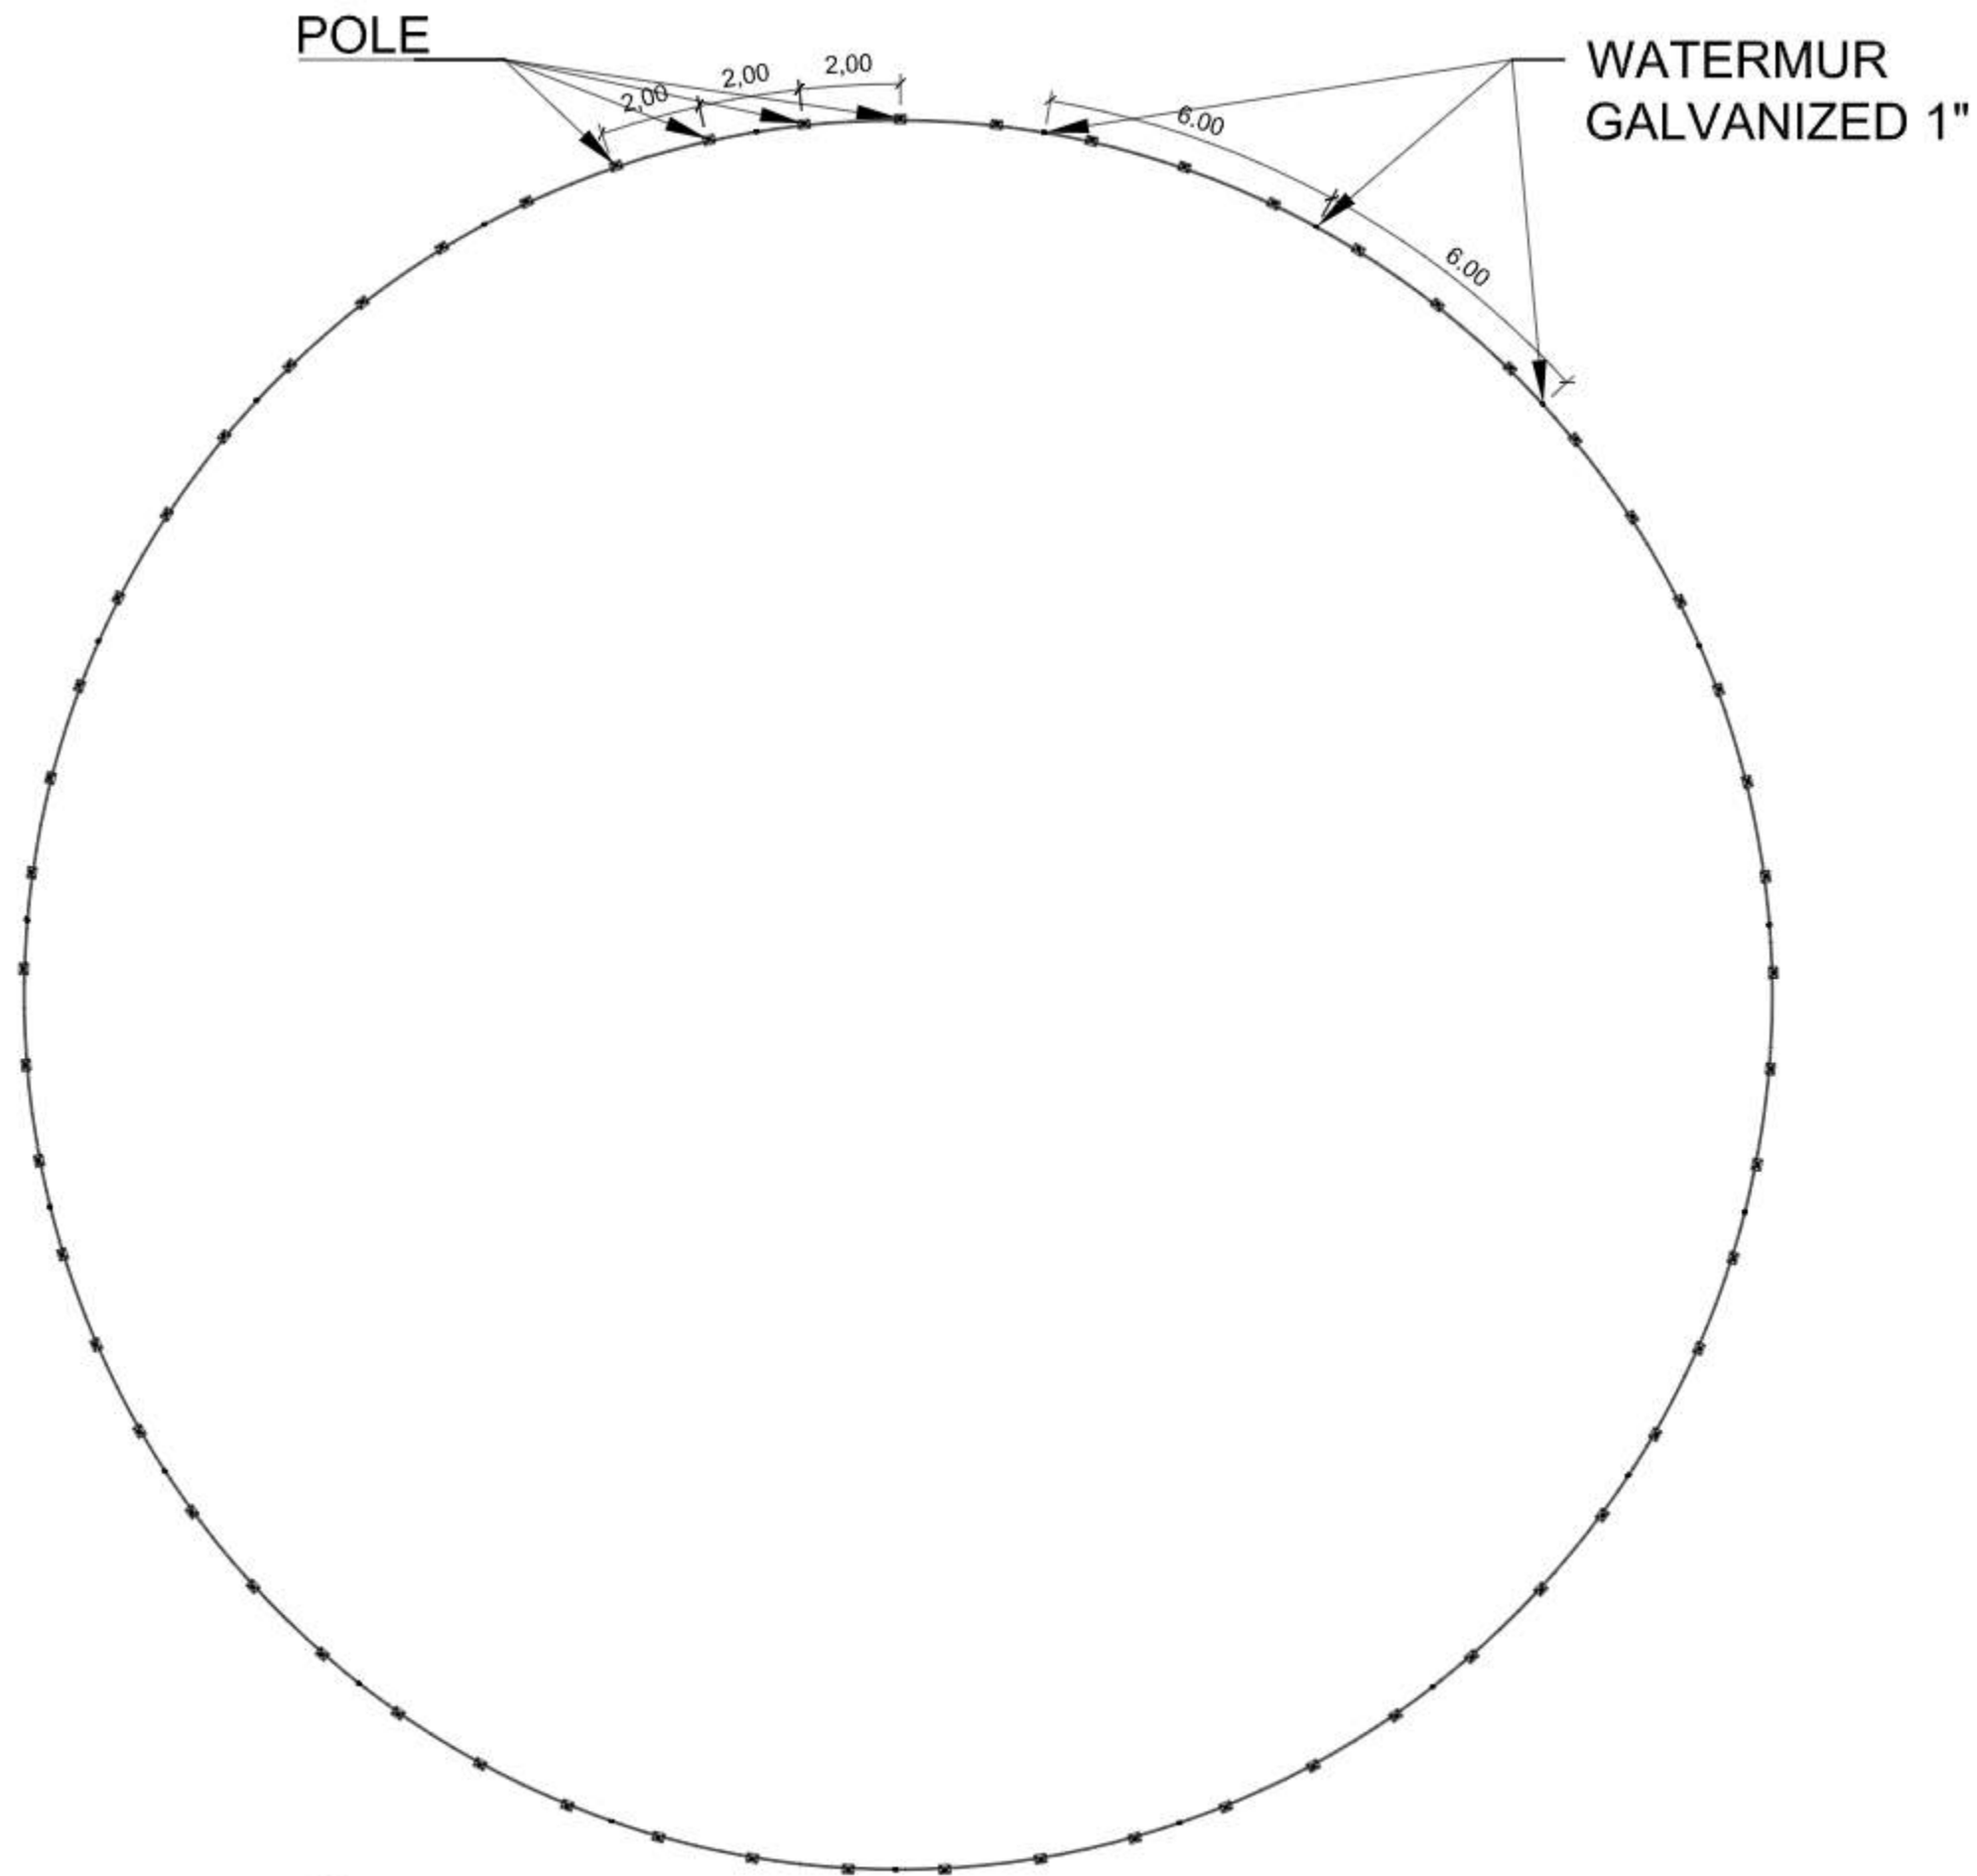

RENCANA TIANG KOLAM

SKALA 1 : 150



PEMBERI TUGAS



KEMENTERIAN KELAUTAN DAN PERIKANAN
DIREKTORAT JENDERAL PERIKANAN BUDI DAYA
INFRASTRUCTURE IMPROVEMENT OF SHRIMP AQUACULTURE PROJECT (ISAP)
JALAN MEDAN MERDEKA TIMUR NOMOR 16
JAKARTA 10110 KOTAK POS 4190 JKP 10041
TELEPON (021) 5518179 (LACAK), FAKS (021) 2514772
LAMARAN www.mkp.go.id SUREL aq@mp.go.id

PEKERJAAN

GAMBAR DETAIL ENGINEERING DESIGN (DED)
TAMBAK UPT

LOKASI

DESA DATA, KEC. DUAM PANUA
KAB. PINRANG, PROV. SULAWESI SELATAN

REVISI

NO	TGL	LOKASI	GMBR	DICEK	DISETUJUI

KONSULTAN PERENCANA



PT. DUTA CIPTA MANDIRI ENGINEERING CONSULTANT

AND IN SUB CONSULTANCY WITH



PT. SUCOFINDO ADVISORY UTAMA



PT. INAME UTAMA



PT. CAKRA BUANA AGHNA

DISUSUN :


Dr. Ir. BAMBANG SUMARTONO, M.Sc.
Aquaculture Specialist (Team Leader) [AQSTL]

DISETUJUI :

PEJABAT PEMBUAT KOMITMEN
INFRASTRUCTURE IMPROVEMENT OF SHRIMP AQUACULTURE PROJECT

SOLEHUDIN ABDUL GANI, S.Pi
NIP. 19700727 200112 1 001

JUDUL GAMBAR		SKALA
DENAH RENCANA TIANG KOLAM		1 : 150
KODE GAMBAR	HAL. GAMBAR	TAHUN
LDK-07.02	-	2024

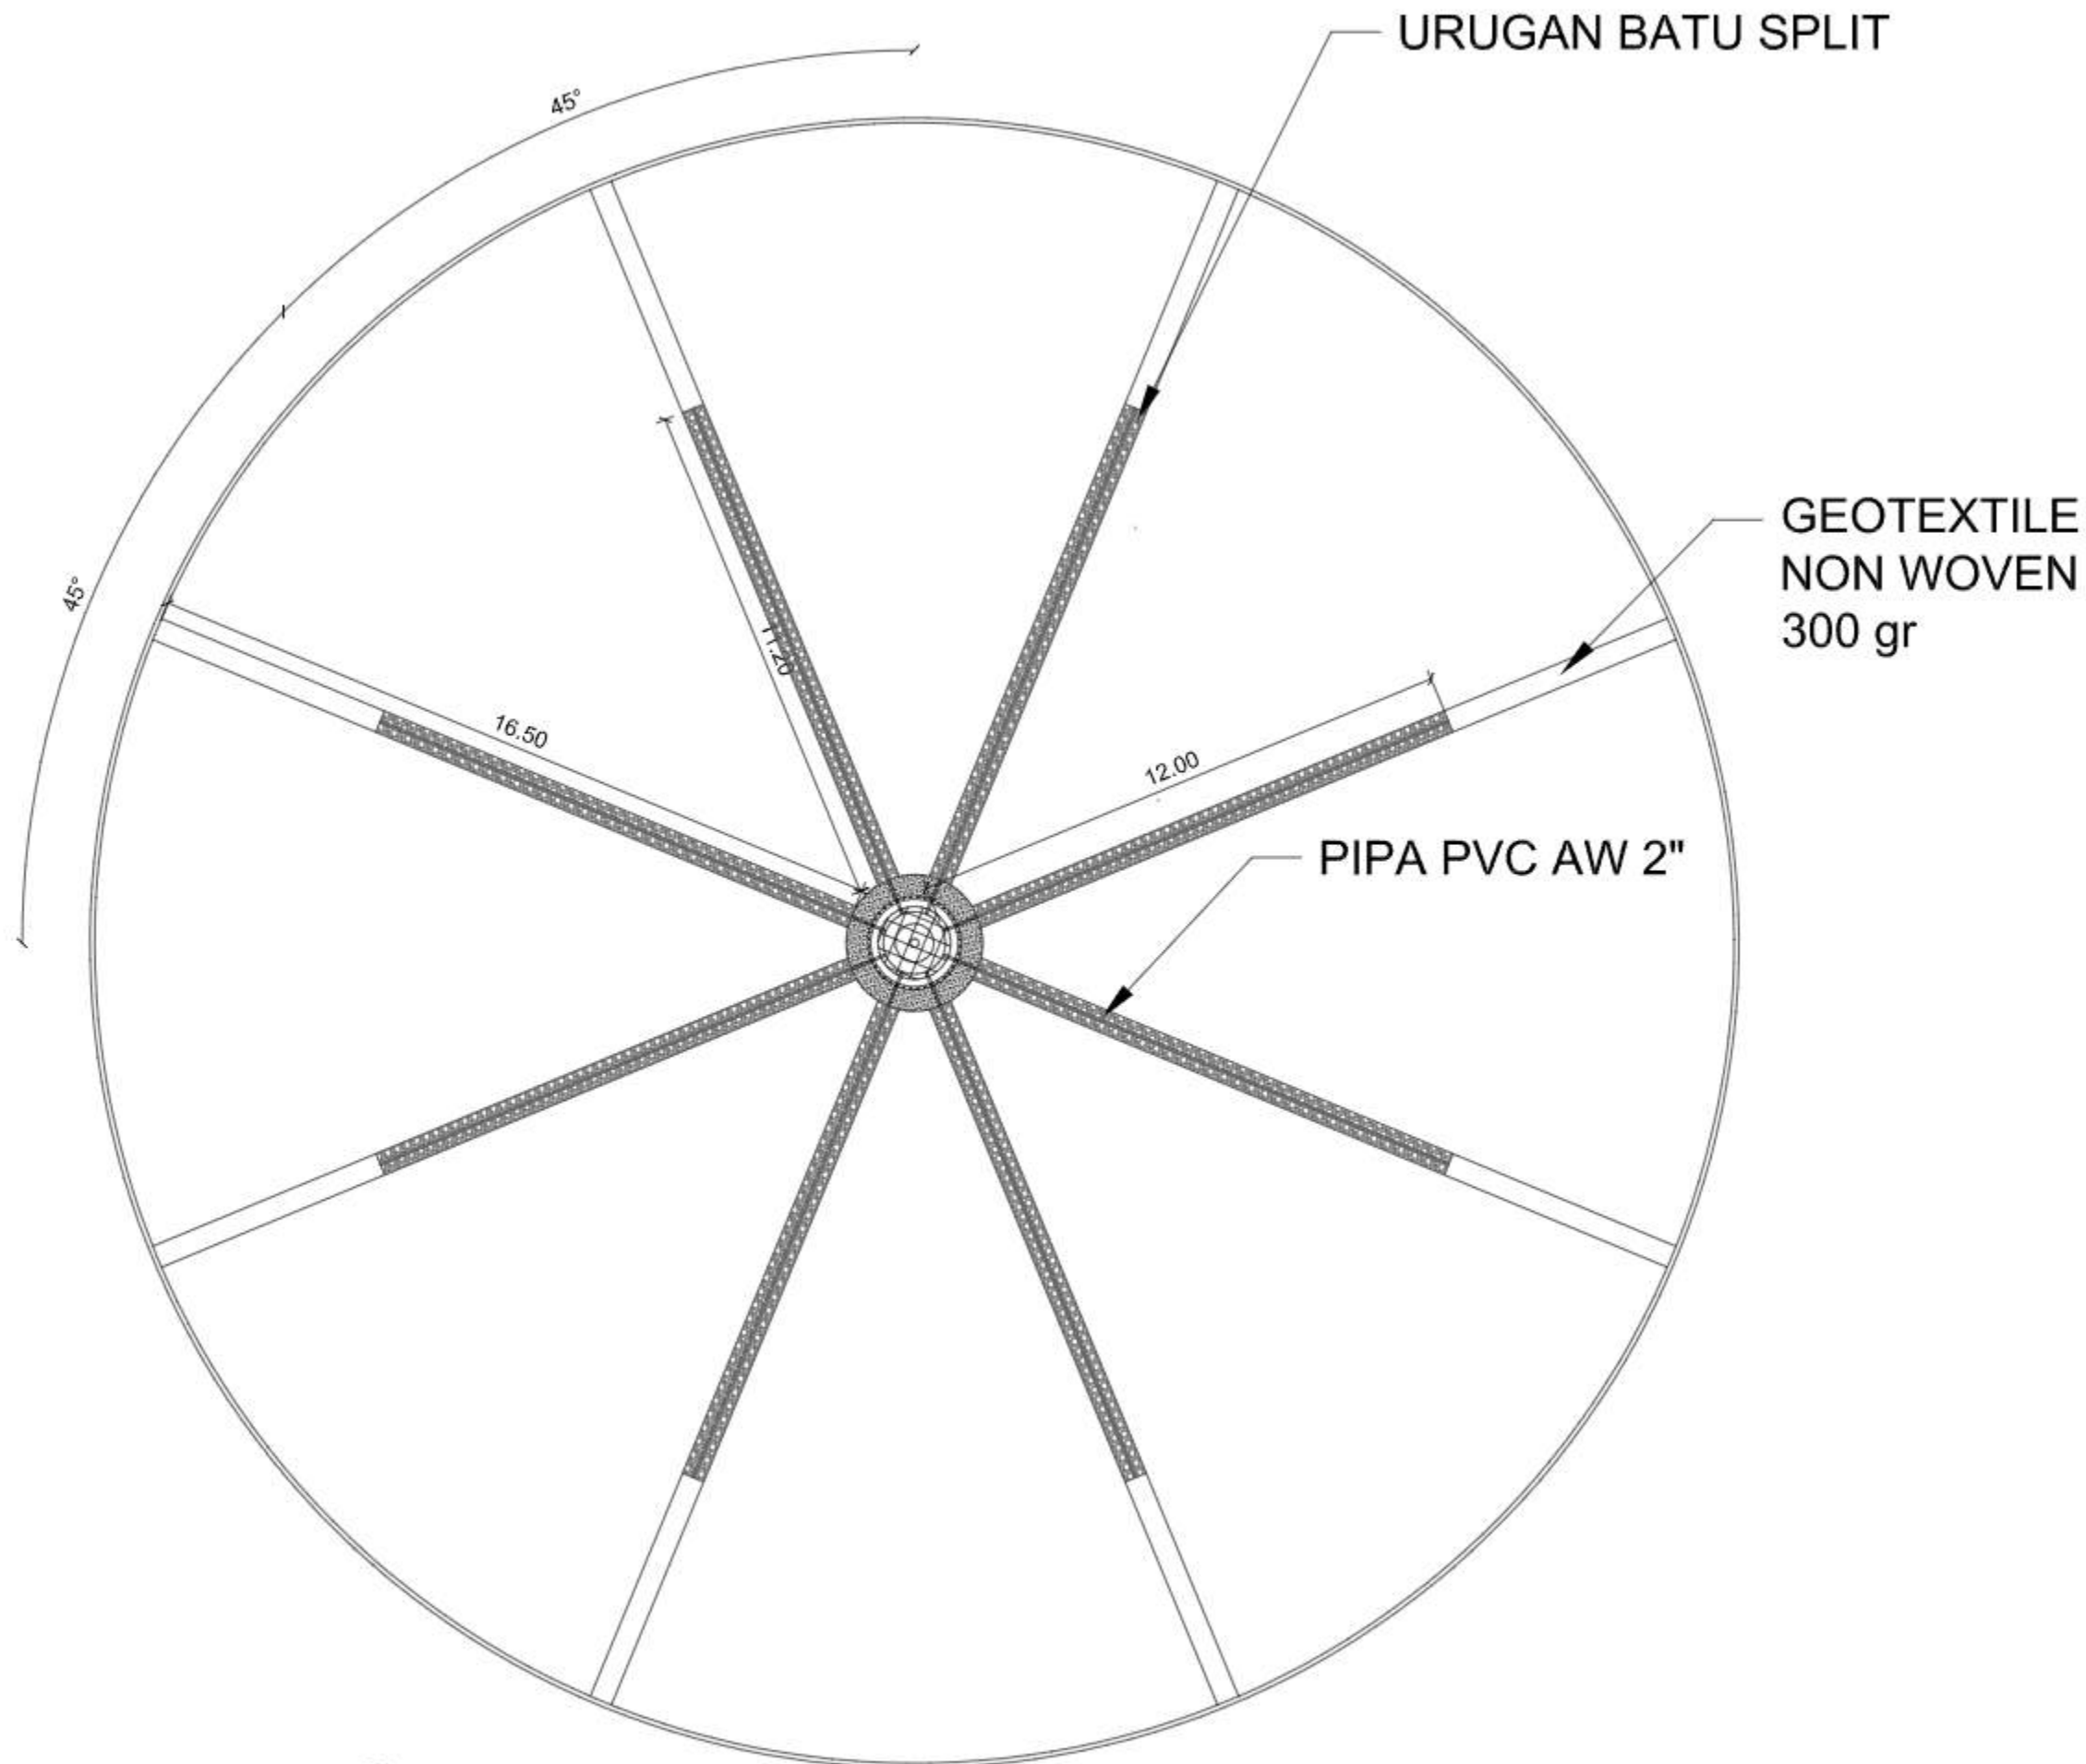

DENAH RESAPAN KOLAM

SKALA 1 : 150



PEMBERI TUGAS



KEMENTERIAN KELAUTAN DAN PERIKANAN
DIREKTORAT JENDERAL PERIKANAN BUDI DAYA
INFRASTRUCTURE IMPROVEMENT OF SHRIMP AQUACULTURE PROJECT (ISAP)
JALAN MEDAN MERDEKA TRAJUR NOMER 16
JAKARTA 10110 KOTAK POS 4190 JKP 10041
TELEPON (021) 2518179 ILACAK, PAKSI BULE (021) 2514772
LAMAN www.kkp.go.id SUREL id@kpp.go.id

PEKERJAAN

GAMBAR DETAIL ENGINEERING DESIGN (DED)
TAMBAK UPT

LOKASI

DESA DATA, KEC. DUAM PANUA
KAB. PINRANG, PROV. SULAWESI SELATAN

REVISI

NO	TGL	LOKASI	GMBR	DICEK	DISETUJUI

KONSULTAN PERENCANA



PT. DUTA CIPTA MANDIRI ENGINEERING CONSULTANT

AND IN SUB CONSULTANCY WITH



PT. SUCOFINDO ADVISORY UTAMA



PT. INAME UTAMA



PT. CAKRA BUANA AGHNA

DISUSUN :

[Signature]

Dr. Ir. BAMBANG SUMARTONO, M.Sc.
Aquaculture Specialist (Team Leader) [AQSTL]


DISETUJUI :

PEJABAT PEMBUAT KOMITMEN
INFRASTRUCTURE IMPROVEMENT OF SHRIMP AQUACULTURE PROJECT

[Signature]


SOLEHJUDIN ABDUL GANI, S.Pi
NIP. 19700727 200112 1 001

JUDUL GAMBAR		SKALA
DENAH RENCANA RESAPAN KOLAM		1 : 150
KODE GAMBAR	HAL GAMBAR	TAHUN
LDK-07.03	-	2024

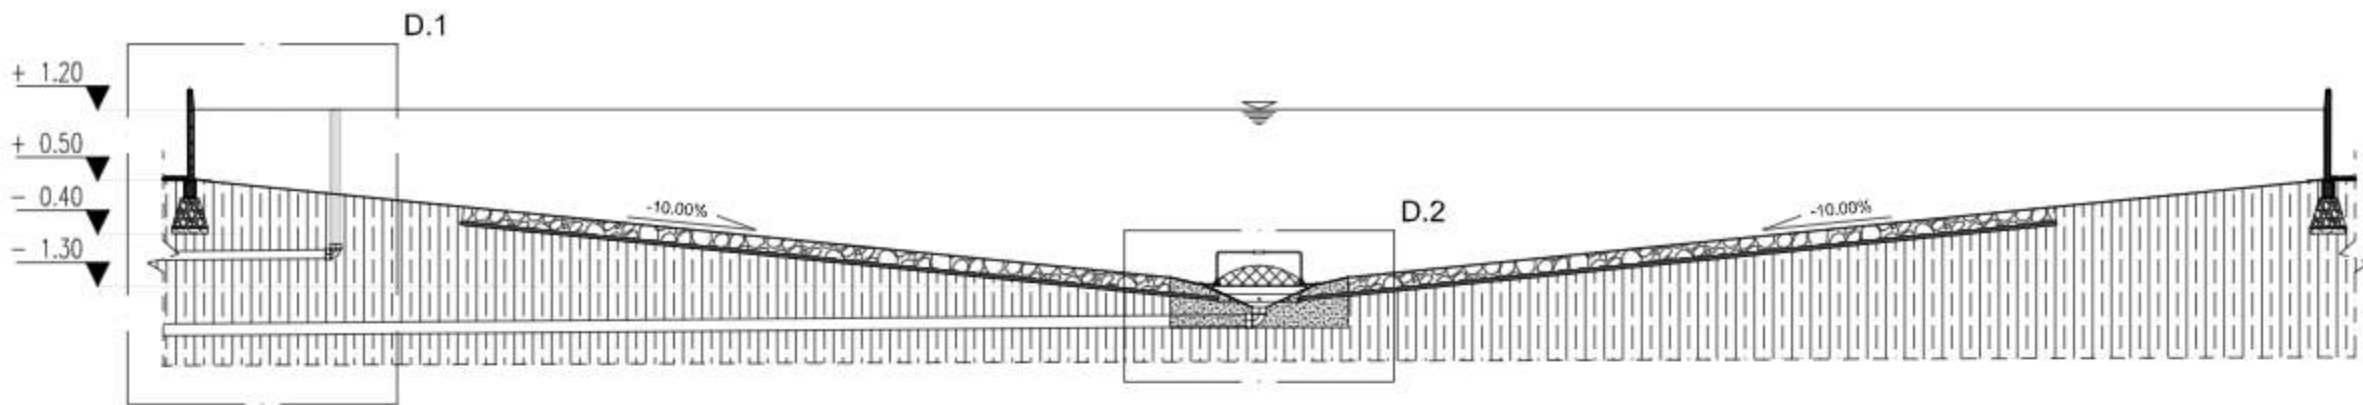


POTONGAN KOLAM

SKALA 1 : 125

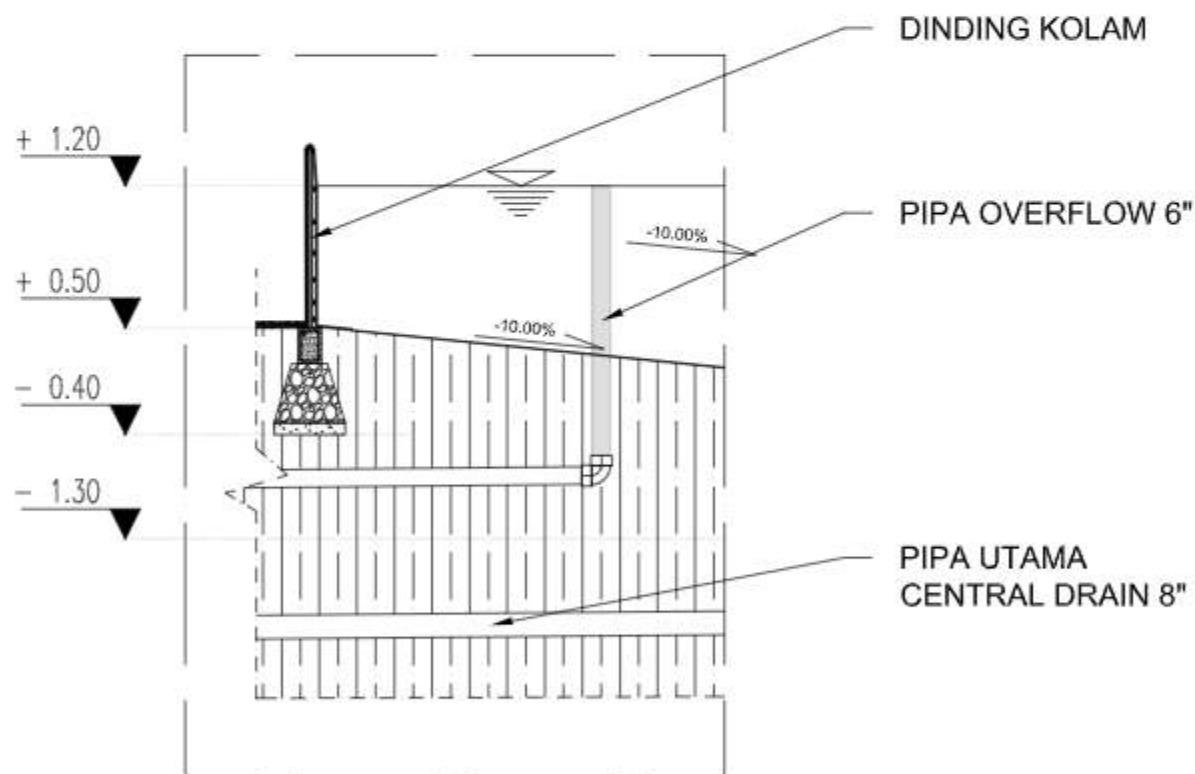

DETAIL D.1

SKALA 1 : 50

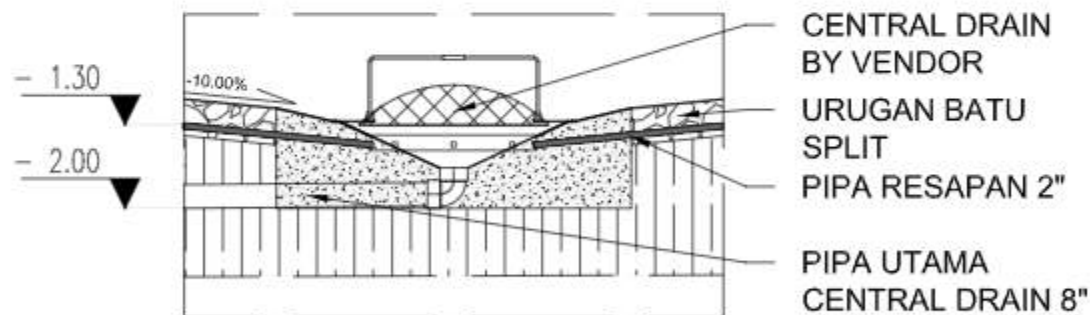

DETAIL D.2

SKALA 1 : 50



PEMBERI TUGAS



KEMENTERIAN KELAUTAN DAN PERIKANAN
DIREKTORAT JENDERAL PERIKANAN BUDI DAYA
INFRASTRUCTURE IMPROVEMENT OF SHRIMP AQUACULTURE PROJECT (ISAP)
JALAN MEDAN MERDEKA TIMUR NOMOR 16
JAKARTA 10110 KOTAK POS 4156 JKP 10541
TELEPON (021) 3518079 ILACAK, PANGSIBELE (021) 2514772
LAMARAN www.kkp.go.id SUREL a@knp.go.id

PEKERJAAN

GAMBAR DETAIL ENGINEERING DESIGN (DED)
TAMBAK UPT

LOKASI

DESA DATA, KEC. DUAM PANUA
KAB. PINRANG, PROV. SULAWESI SELATAN

REVISI

NO	TGL	LOKASI	GMBR	DICEK	DISETUJUI

KONSULTAN PERENCANA



PT. DUTA CIPTA MANDIRI ENGINEERING CONSULTANT

AND IN SUB CONSULTANCY WITH



PT. SUCOFINDO ADVISORY UTAMA



PT. INAME UTAMA



PT. CAKRA BUANA AGHNA

DISUSUN :

[Signature]

Dr. Ir. BAMBANG SUMARTONO, M.Sc.
Aquaculture Specialist (Team Leader) [AQSTL]

DISETUJUI :

PEJABAT PEMBUAT KOMITMEN
INFRASTRUCTURE IMPROVEMENT OF SHRIMP AQUACULTURE PROJECT

[Signature]

SOLEHJUDIN ABDUL GANI, S.Pi
NIP. 19700727 200112 1 001

JUDUL GAMBAR

SKALA

POTONGAN DAN DETAIL KOLAM

1 : 125
1 : 50

KODE GAMBAR


HAL GAMBAR

TAHUN


LDK-07.04

-


2024

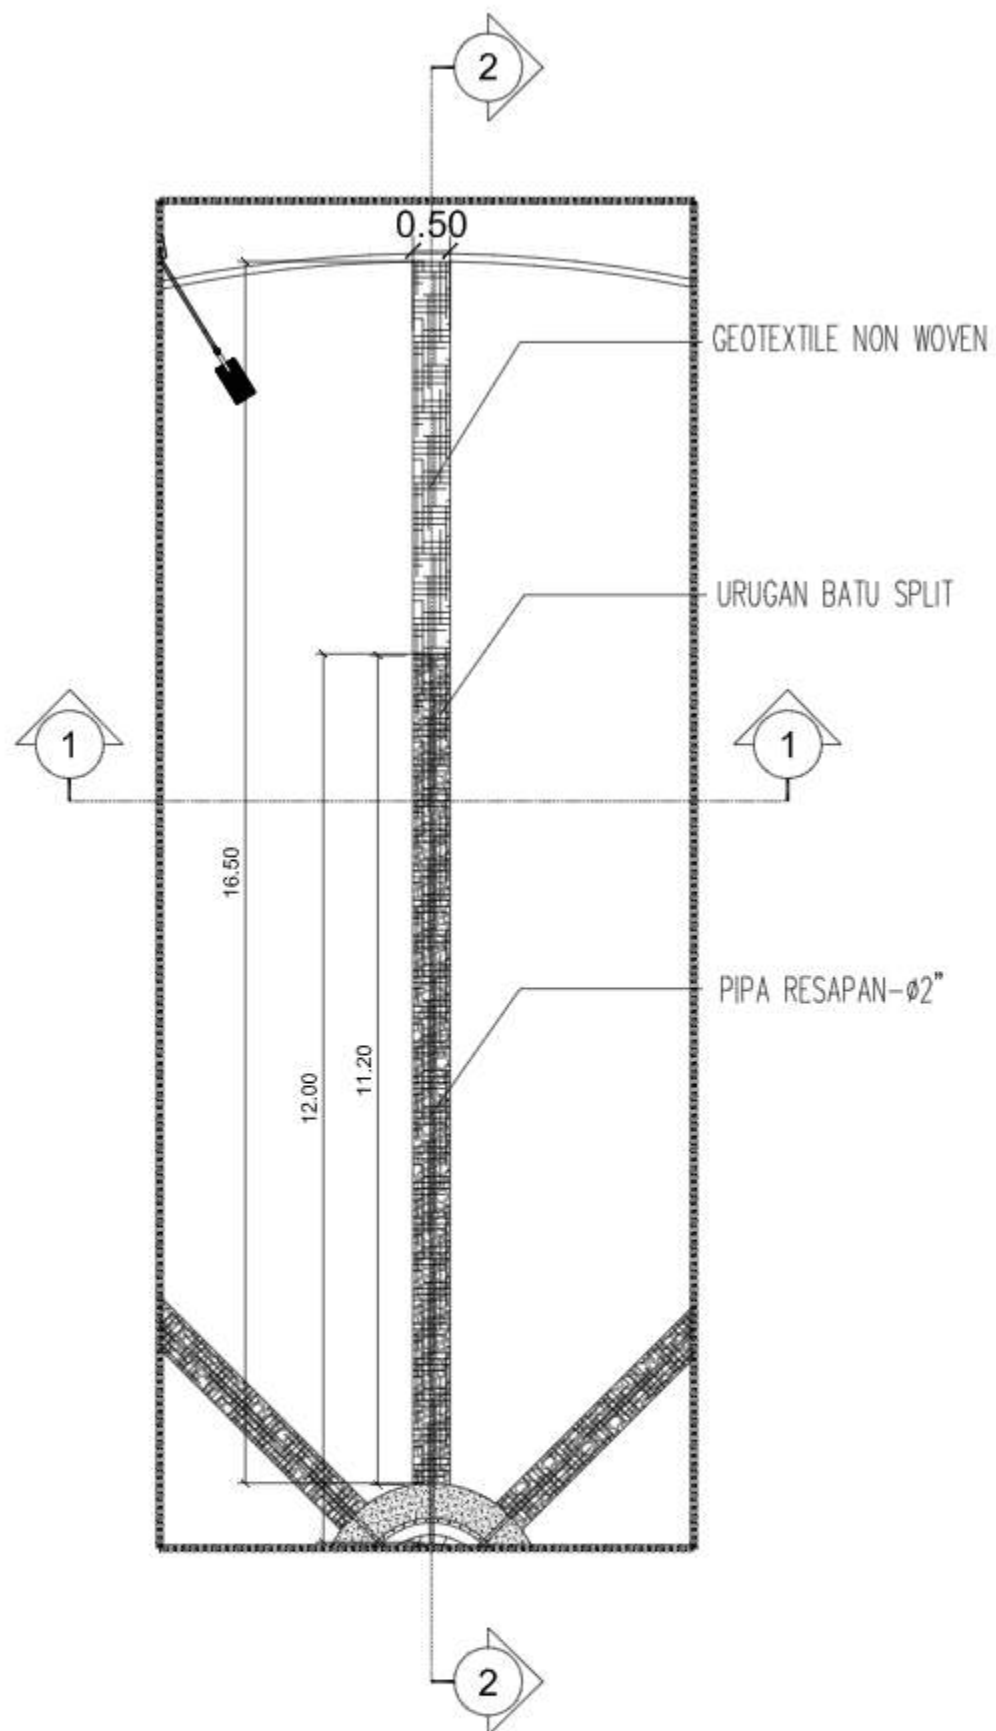

DETAIL - 03
SKALA 1 : 100

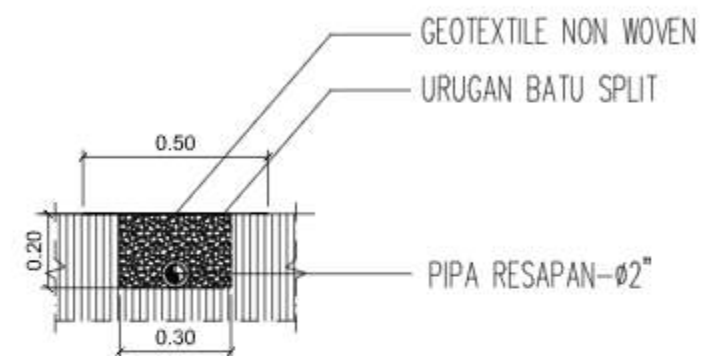

POTONGAN 1-1
SKALA 1 : 20

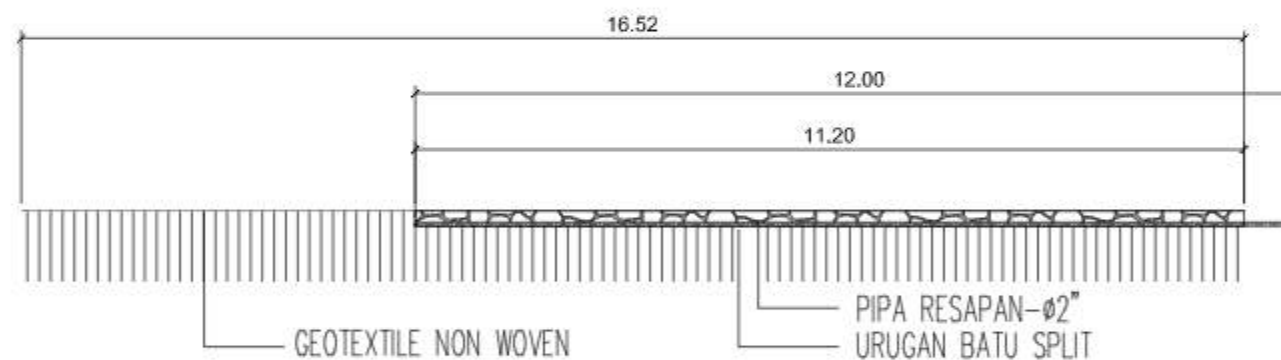

POTONGAN 2-2
SKALA 1 : 100

PEMBERI TUGAS



KEMENTERIAN KELAUTAN DAN PERIKANAN
DIREKTORAT JENDERAL PERIKANAN BUDI DAYA
INFRASTRUCTURE IMPROVEMENT OF SHRIMP AQUACULTURE PROJECT (ISAP)
JALAN MEDAN MERDEKA TIMUR NOMOR 16
JAKARTA 10110 KOTAK POS 4130 JKP 10041
TELEPON (021) 3019070-8 ACARA, PANGSAL, E 10211 3514772
LAMARAN www.kkp.go.id SUREL @kpp@kp.go.id

PEKERJAAN

GAMBAR DETAIL ENGINEERING DESIGN (DED)
TAMBAK UPT

LOKASI

DESA DATA, KEC. DUAM PANUA
KAB. PINRANG, PROV. SULAWESI SELATAN

REVISI

NO	TGL	LOKASI	GMBR	DICEK	DISETUJUI

KONSULTAN PERENCANA



PT. DUTA CIPTA MANDIRI ENGINEERING CONSULTANT

AND IN SUB CONSULTANCY WITH



PT. SUCOFINDO ADVISORY UTAMA



PT. INAME UTAMA



PT. CAKRA BUANA AGHNA

DISUSUN :

[Signature]

Dr. Ir. BAMBANG SUMARTONO, M.Sc.
Aquaculture Specialist (Team Leader) [AQ&TL]


DISETUJUI :

PEJABAT PEMBUAT KOMITMEN
INFRASTRUCTURE IMPROVEMENT OF SHRIMP AQUACULTURE PROJECT


[Signature]

SOLEHUDIN ABDUL GANI S.PI
NIP. 19700727 200112 1 001


JUDUL GAMBAR		SKALA
DETAIL PIPA RESAPAN KOLAM		1 : 100 1 : 20
KODE GAMBAR	HAL. GAMBAR	TAHUN
LDK-07.05	-	2024

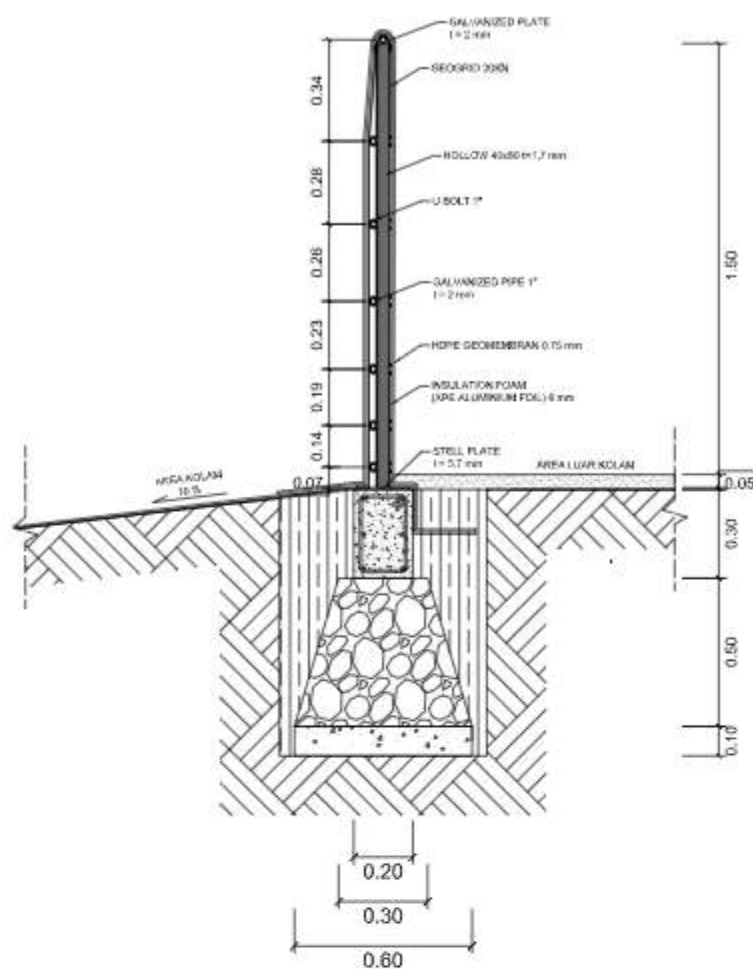


POTONGAN DINDING KOLAM
SKALA 1 : 50

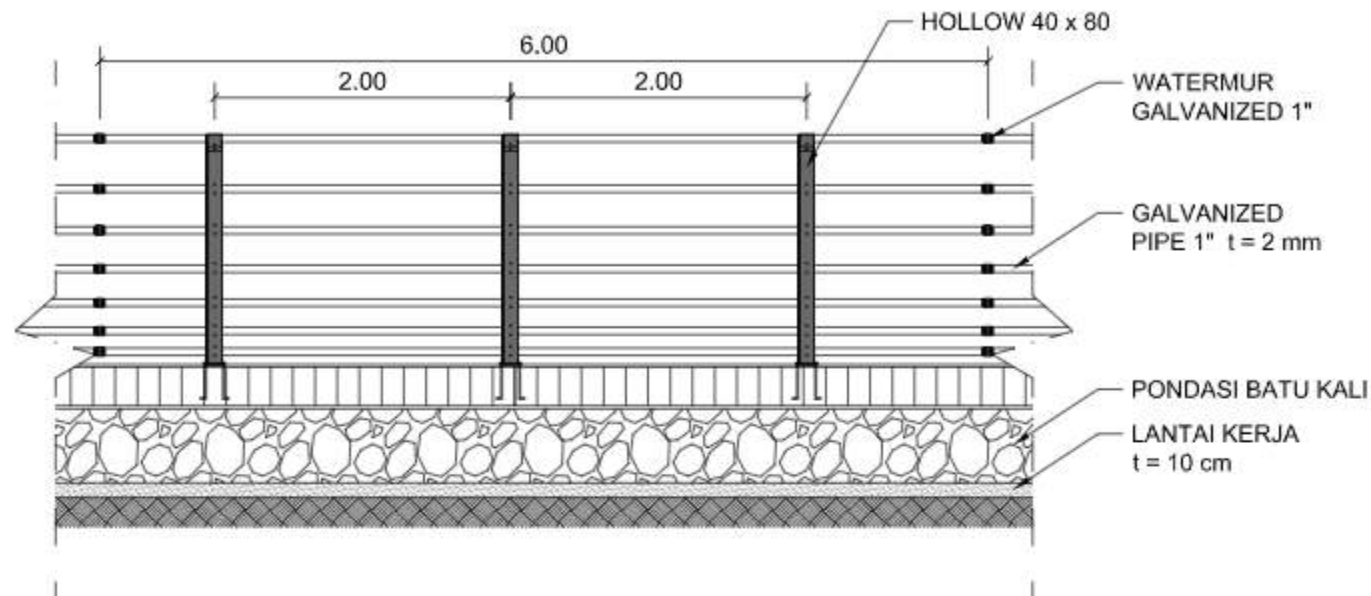


DETAIL DINDING KOLAM
SKALA 1 : 100

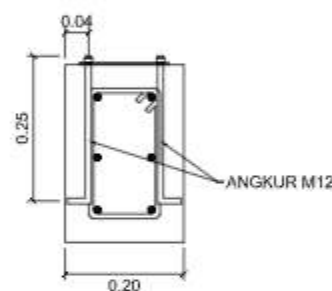


DETAIL ANGKUR
SKALA 1 : 25

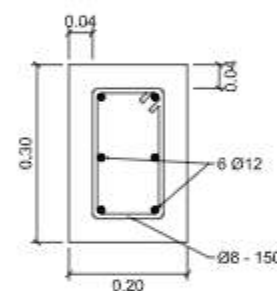


DETAIL SLOOF
SKALA 1 : 25

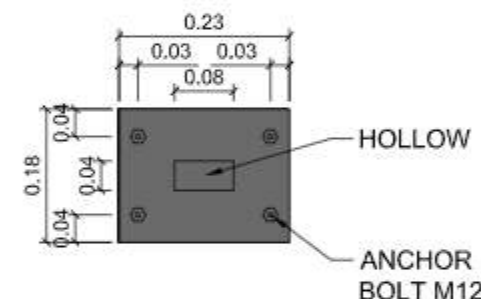


DETAIL BASE PLATE
SKALA 1 : 50

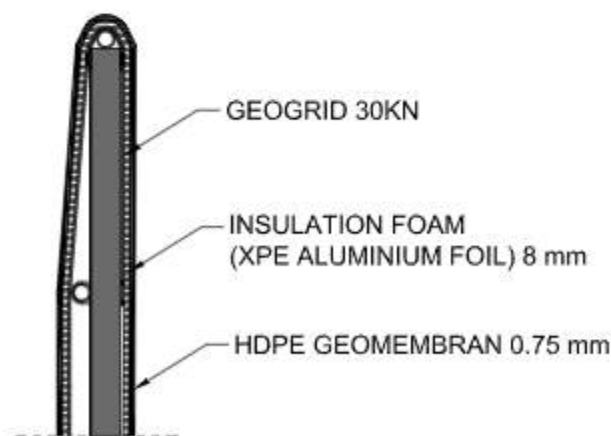

DETAIL LAPISAN DINDING
SKALA 1 : 5

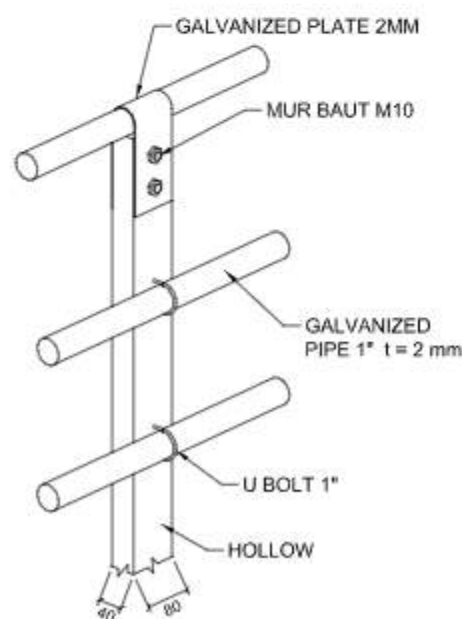


DETAIL ISOMETRI TIANG KOLAM
SKALA 1 : 50

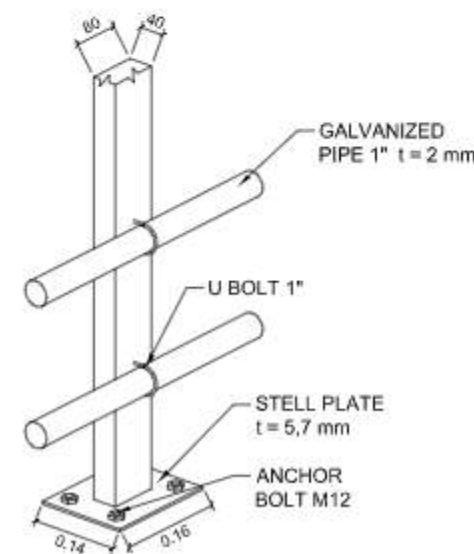


DETAIL ISOMETRI TIANG KOLAM
SKALA 1 : 50

PEMBERI TUGAS  KEMENTERIAN KELAUTAN DAN PERIKANAN DIREKTORAT JENDERAL PERIKANAN BUDI DAYA INFRASTRUCTURE IMPROVEMENT OF SHRIMP AQUACULTURE PROJECT (ISAP) JALAN MEDAN MERDEKA TIMUR NOMOR 16 JAKARTA 10110 KOTAK POS 4130 JKP 10041 TELEPON (021) 3019070-8 ACARA, PANGSABE 021 3516772 LAMARAN www.kkp.go.id SUREL @knpa@kp.go.id					
PEKERJAAN					
GAMBAR DETAIL ENGINEERING DESIGN (DED) TAMBAK UPT					
LOKASI					
DESA DATA, KEC. DUAM PANUA KAB. PINRANG, PROV. SULAWESI SELATAN					
REVISI					
NO	TGL	LOKASI	GMBR	DICEK	DISETUJUI
KONSULTAN PERENCANA					
 PT. DUTA CIPTA MANDIRI ENGINEERING CONSULTANT AND IN SUB CONSULTANCY WITH  PT. SUCOFINDO ADVISORY UTAMA  PT. INAME UTAMA  PT. CAKRA BUANA AGHNA					
DISUSUN :					
 Dr. Ir. BAMBANG SUMARTONO, M.Sc. Aquaculture Specialist (Team Leader) [AQ&TL]					
DISETUJUI :					
PEJABAT PEMBUAT KOMITMEN INFRASTRUCTURE IMPROVEMENT OF SHRIMP AQUACULTURE PROJECT  SOLEHUDIN ABDUL GANI, S.Pi NIP. 19700727 200112 1 001					
JUDUL GAMBAR		SKALA			
DETAIL DINDING KOLAM		1 : 100 1 : 50 1 : 25			
KODE GAMBAR	HAL. GAMBAR	TAHUN			
LDK-07.06	-	2024			

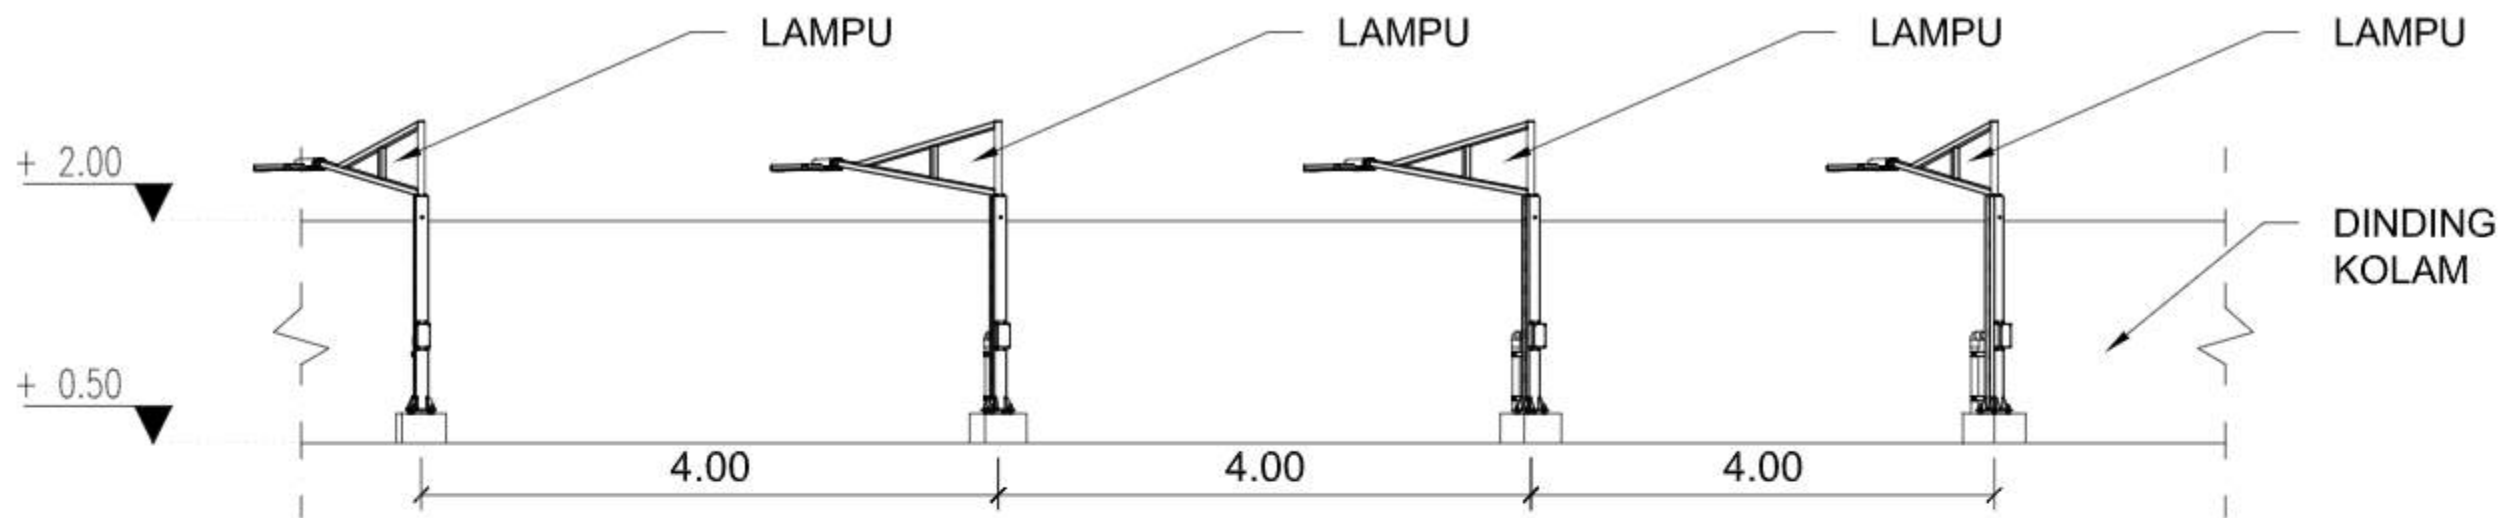


TAMPAK LAMPU

SKALA 1 : 50

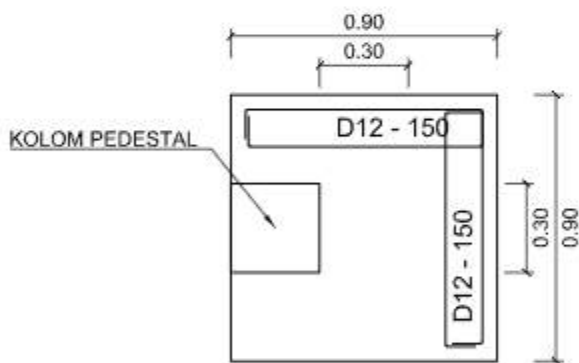


DENAH PONDASI

SKALA 1 : 50

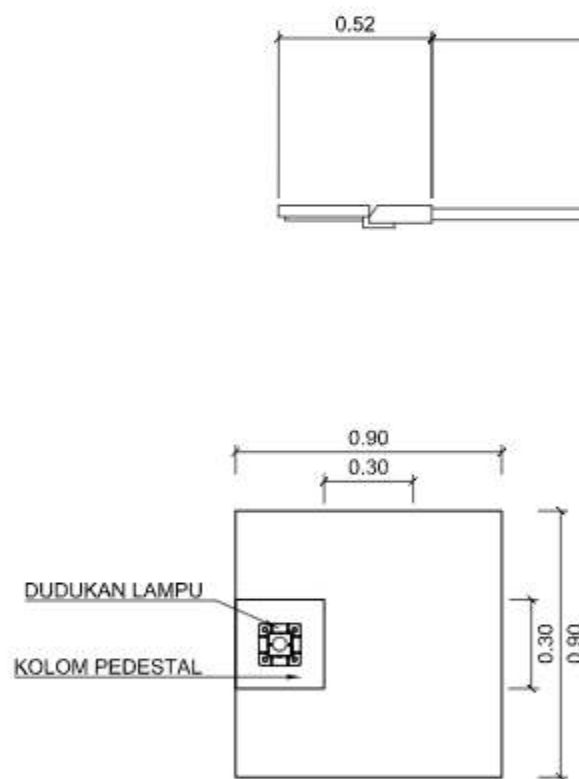

DENAH BASE PLATE LAMPU

SKALA 1 : 50

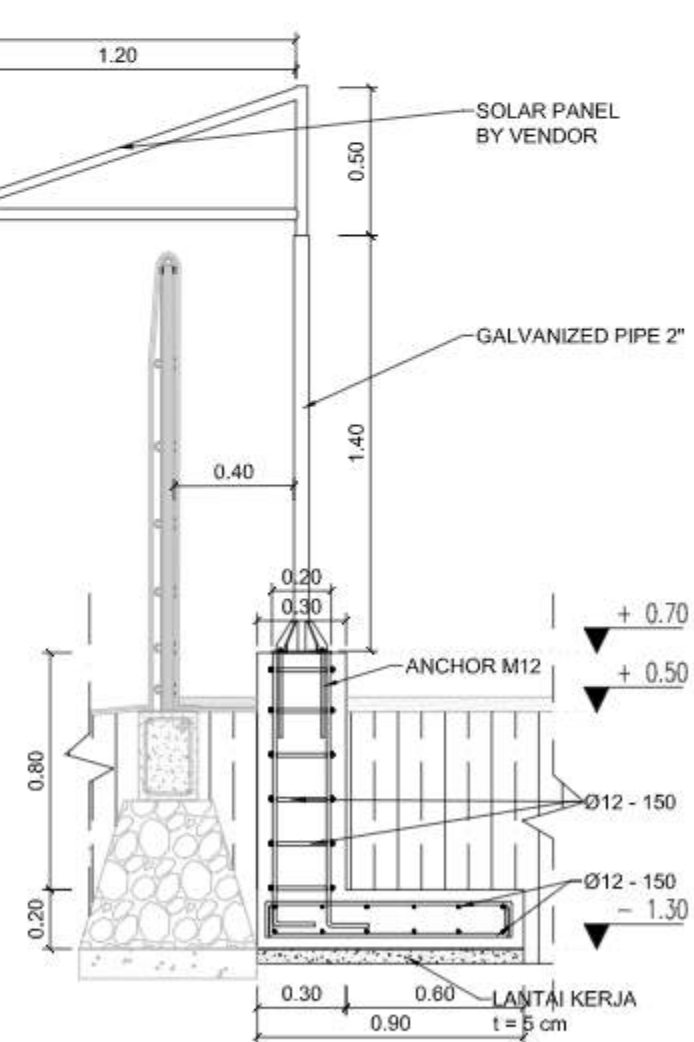

DETAIL POTONGAN PONDASI LAMPU

SKALA 1 : 50

PEMBERI TUGAS



KEMENTERIAN KELAUTAN DAN PERIKANAN
DIREKTORAT JENDERAL PERIKANAN BUDI DAYA
INFRASTRUCTURE IMPROVEMENT OF SHRIMP AQUACULTURE PROJECT (ISAP)
JALAN MEDAN MERDEKA TIMUR NO. 16
JAKARTA 10110 KOTAK POS 4130 JKP 10041
TELEPON (021) 3019070-8 ACARA, PANGSABE 10211 2516772
LAMARAN www.kemtan.go.id SUREL @kemtan.go.id

PEKERJAAN

GAMBAR DETAIL ENGINEERING DESIGN (DED)
TAMBAK UPT

LOKASI

DESA DATA, KEC. DUAM PANUA
KAB. PINRANG, PROV. SULAWESI SELATAN

REVISI

NO	TGL	LOKASI	GMBR	DICEK	DISETUJUI

KONSULTAN PERENCANA



PT. DUTA CIPTA MANDIRI ENGINEERING CONSULTANT

AND IN SUB CONSULTANCY WITH



PT. SUCOFINDO ADVISORY UTAMA



PT. INAME UTAMA



PT. CAKRA BUANA AGHNA

DISUSUN :

[Signature]

Dr. Ir. BAMBANG SUMARTONO, M.Sc.
Aquaculture Specialist (Team Leader) [AQ&TL]


DISETUJUI :

PEJABAT PEMBUAT KOMITMEN
INFRASTRUCTURE IMPROVEMENT OF SHRIMP AQUACULTURE PROJECT

[Signature]


SOLEHUDIN ABDUL GANI, S.Pi
NIP. 19700727 200112 1 001

JUDUL GAMBAR		SKALA
DETAIL LAMPU KOLAM		1 : 50
KODE GAMBAR	HAL. GAMBAR	TAHUN
LDK-07.07	-	2024

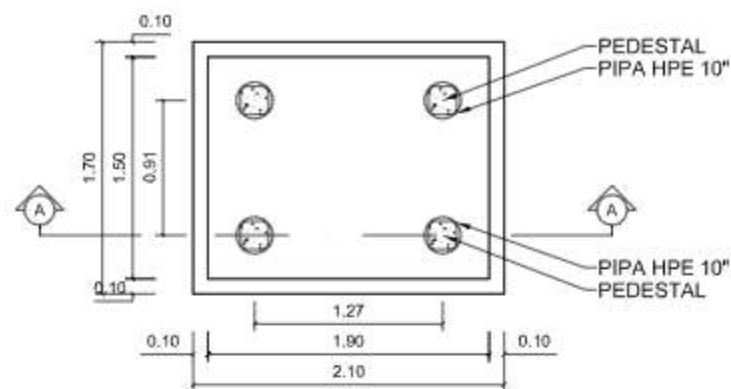


DENAH PONDASI MFD

SKALA 1 : 50

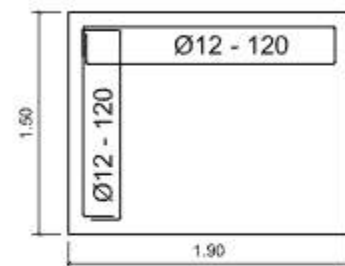


DETAIL PEMBESIAN

SKALA 1 : 50

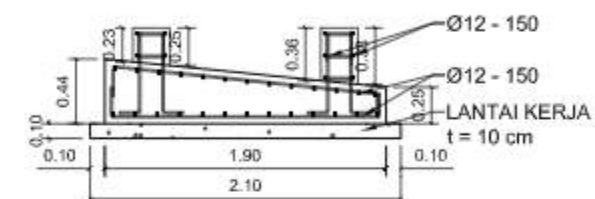


POTONGAN A - A

SKALA 1 : 50

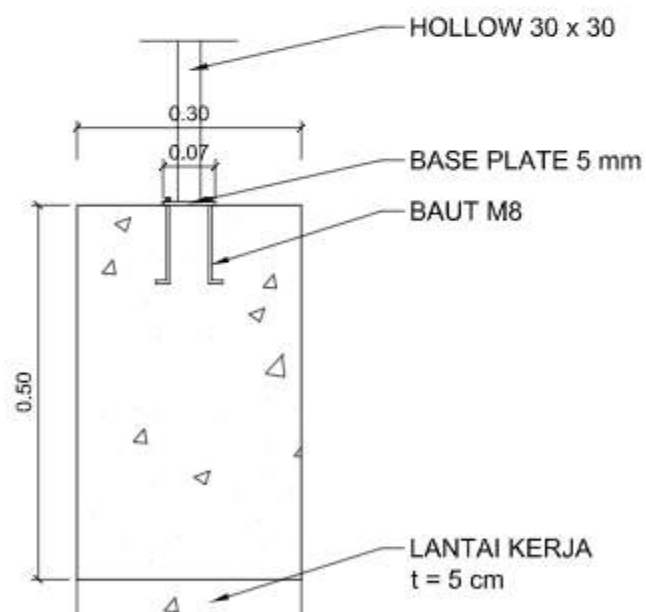

POTONGAN 1 - 1

SKALA 1 : 20

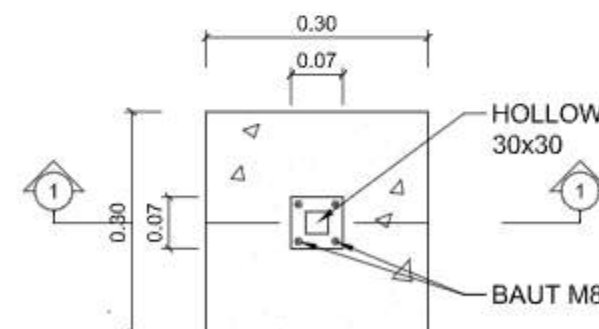

DENAH PONDASI TANGGA

SKALA 1 : 20

PEMBERI TUGAS



KEMENTERIAN KELAUTAN DAN PERIKANAN
DIREKTORAT JENDERAL PERIKANAN BUDI DAYA
INFRASTRUCTURE IMPROVEMENT OF SHRIMP AQUACULTURE PROJECT (ISAP)
JALAN MEDAN MERDEKA TIMUR NOMOR 16
JAKARTA 10110 KOTAK POS 4130 JKP 10041
TELEPON (021) 3519070-8 ACARA, PANGSABE (021) 3514772
LAMARAN www.kkp.go.id SUREL @kppa@kp.go.id

PEKERJAAN

GAMBAR DETAIL ENGINEERING DESIGN (DED)
TAMBAK UPT

LOKASI

DESA DATA, KEC. DUAM PANUA
KAB. PINRANG, PROV. SULAWESI SELATAN

REVISI

NO	TGL	LOKASI	GMBR	DICEK	DISETUJUI

KONSULTAN PERENCANA



PT. DUTA CIPTA MANDIRI ENGINEERING CONSULTANT

AND IN SUB CONSULTANCY WITH



PT. SUCOFINDO ADVISORY UTAMA



PT. INAME UTAMA



PT. CAKRA BUANA AGHNA

DISUSUN :

[Signature]

Dr. Ir. BAMBANG SUMARTONO, M.Sc.
Aquaculture Specialist (Team Leader) [AQ&TL]


DISETUJUI :

PEJABAT PEMBUAT KOMITMEN
INFRASTRUCTURE IMPROVEMENT OF SHRIMP AQUACULTURE PROJECT


[Signature]

SOLEHUDIN ABDUL GANI, S.Pi
NIP. 19700727 200112 1 001


JUDUL GAMBAR		SKALA
DETAIL PONDASI MFD DAN PONDASI TANGGA		1 : 50 1 : 20
KODE GAMBAR	HAL. GAMBAR	TAHUN
LDK-07.09	-	2024

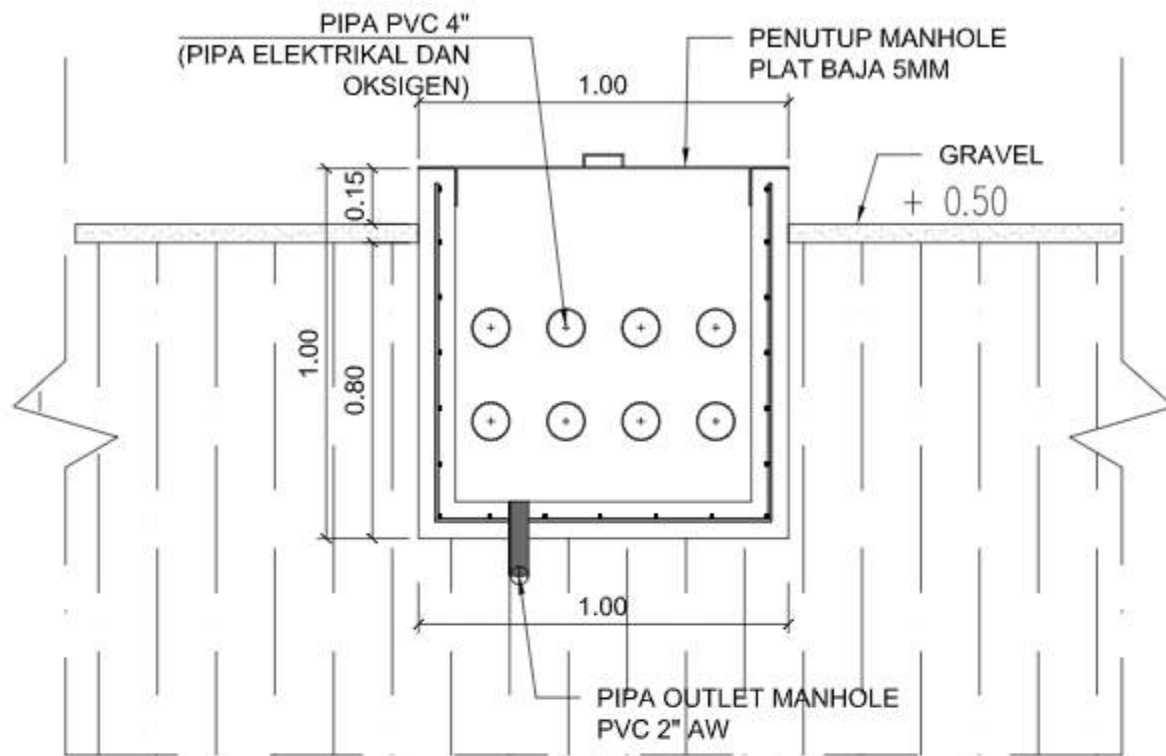


POTONGAN 1 - 1
SKALA 1 : 20

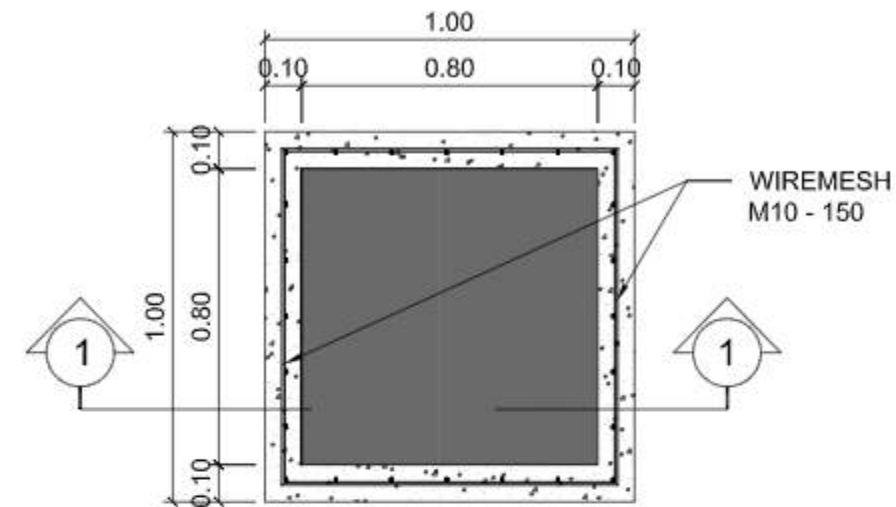

DENAH MANHOLE
SKALA 1 : 25

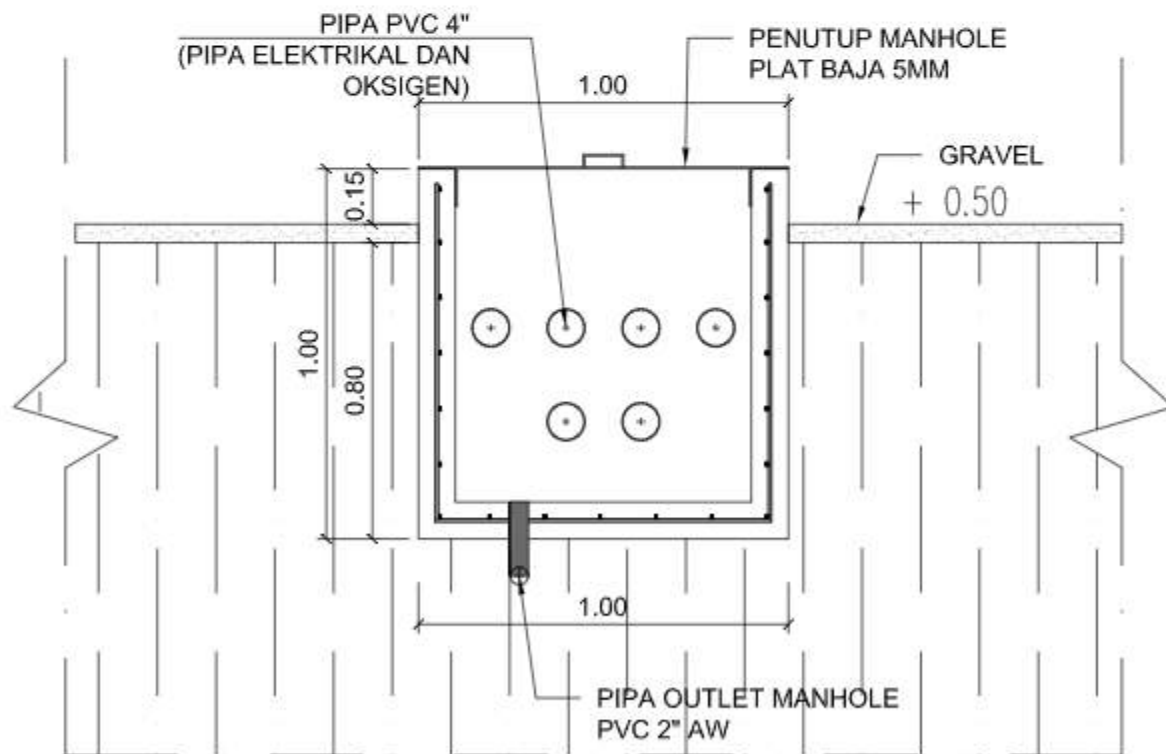


POTONGAN 1 - 1
SKALA 1 : 20

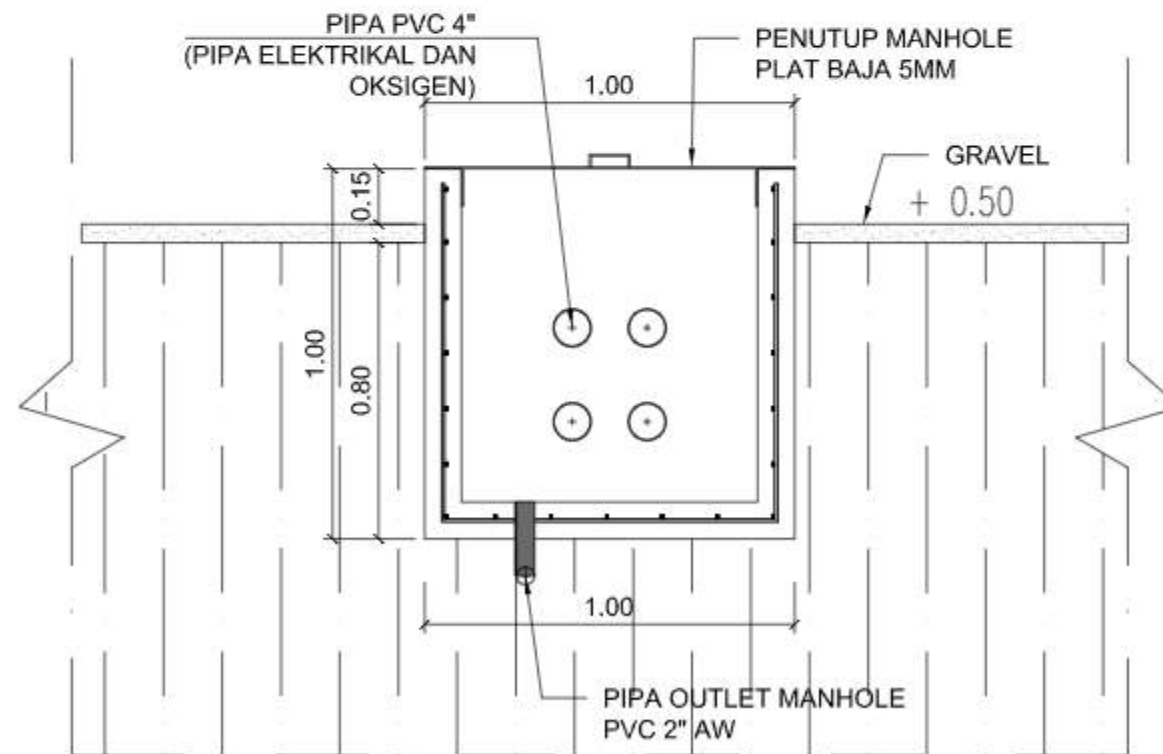


POTONGAN 1 - 1
SKALA 1 : 20

 KEMENTERIAN KELAUTAN DAN PERIKANAN DIREKTORAT JENDERAL PERIKANAN BUDI DAYA INFRASTRUCTURE IMPROVEMENT OF SHRIMP AQUACULTURE PROJECT (ISAP) JALAN MEDAN MERDEKA TRAJUR NOMOR 16 JAKARTA 10110 KOTAK POS 4150 JKP 10541 TELEPON (021) 2518079 (LACAK), FAKS/BULE (021) 2514772 LAMAN www.kp.go.id SUREL id@kopo@kpp.go.id					
PEKERJAAN					
GAMBAR DETAIL ENGINEERING DESIGN (DED) TAMBAK UPT					
LOKASI					
DESA DATA, KEC. DUAM PANUA KAB. PINRANG, PROV. SULAWESI SELATAN					
REVISI					
NO	TGL	LOKASI	GMBR	DICEK	DISETUJUI
KONSULTAN PERENCANA					
 PT. DUTA CIPTA MANDIRI ENGINEERING CONSULTANT AND IN SUB CONSULTANCY WITH  PT. SUCOFINDO ADVISORY UTAMA  PT. INAME UTAMA  PT. CAKRA BUANA AGHNA					
DISUSUN :					
 Dr. Ir. BAMBANG SUMARTONO, M.Sc Aquaculture Specialist (Team Leader) [AQSTL]					
DISETUJUI :					
 SOLEHUDIN ABDUL GANI, S.Pi NIP. 19700727 200112 1 001					
JUDUL GAMBAR			SKALA		
DETAIL MANHOLE 1			1 : 20		
KODE GAMBAR	HAL GAMBAR		TAHUN		
LDK-07.10	-		2024		

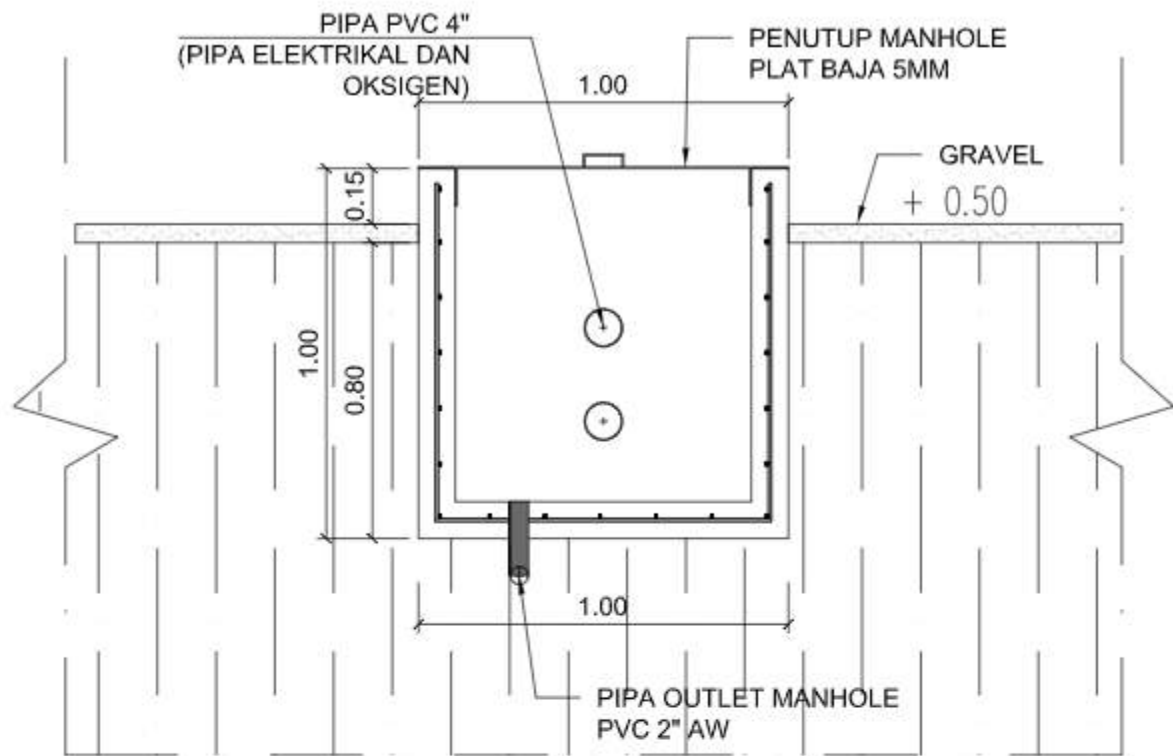


POTONGAN 1 - 1

SKALA 1 : 20

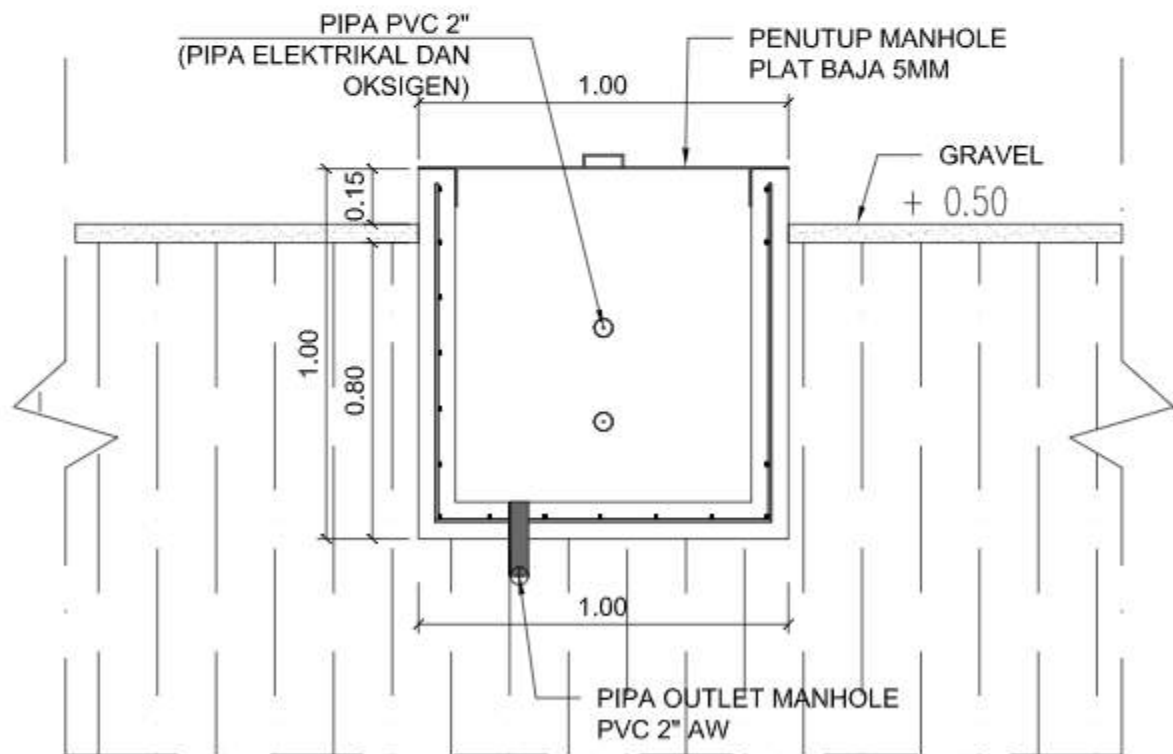

POTONGAN 1 - 1

SKALA 1 : 20

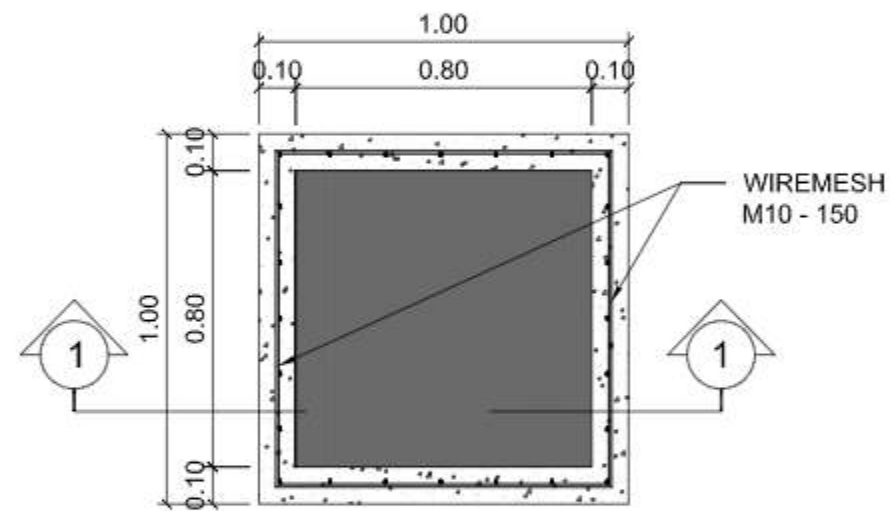

DENAH MANHOLE

SKALA 1 : 25

PEMBERI TUGAS



KEMENTERIAN KELAUTAN DAN PERIKANAN
DIREKTORAT JENDERAL PERIKANAN BUDI DAYA
INFRASTRUCTURE IMPROVEMENT OF SHRIMP AQUACULTURE PROJECT (ISAP)
JALAN MEDAN MERDEKA TRAJUR NOMOR 16
JAKARTA 10110 KOTAK POS 4150 JKP 10541
TELEPON (021) 2518079 ILACAK, PANGSIBELE (021) 2514772
LAMARAN www.kkp.go.id SUREL id@knp.go.id

PEKERJAAN

GAMBAR DETAIL ENGINEERING DESIGN (DED)
TAMBAK UPT

LOKASI

DESA DATA, KEC. DUAM PANUA
KAB. PINRANG, PROV. SULAWESI SELATAN

REVISI

NO	TGL	LOKASI	GMBR	DICEK	DISETUJUI

KONSULTAN PERENCANA

PT. DUTA Cipta Mandiri Engineering Consultant
AND IN SUB CONSULTANCY WITH
PT. SUCOFINDO ADVISORY UTAMA
PT. INAME UTAMA
PT. CAKRA BUANA AGHNA

DISUSUN :

[Signature]

Dr. Ir. BAMBANG SUMARTONO, M.Sc.
Aquaculture Specialist (Team Leader) [AQSTL]

DISETUJUI :

PEJABAT PEMBUAT KOMITMEN
INFRASTRUCTURE IMPROVEMENT OF SHRIMP AQUACULTURE PROJECT

[Signature]

SOLEHUJUDIN ABDUL GANI, S.Pi
NIP. 19700727 200112 1 001

JUDUL GAMBAR		SKALA
DETAIL MANHOLE 2		1 : 20
KODE GAMBAR	HAL. GAMBAR	TAHUN
LDK-07.10	-	2024



PEMBERI TUGAS



KEMENTERIAN KELAUTAN DAN PERIKANAN
DIREKTORAT JENDERAL PERIKANAN BUDI DAYA
INFRASTRUCTURE IMPROVEMENT OF SHRIMP AQUACULTURE PROJECT (ISAP)
JALAN MEDAN MERDEKA TIRUR NOMOR 16
JAKARTA 10110 KOTAK POS 4190 JKP 10041
TELEPON (021) 2518075 (LACAK), FAKS/TELE (021) 2514772
LAJWAB www.lajwab.go.id SUREL ajp@lajwab.go.id

PEKERJAAN

GAMBAR DETAIL ENGINEERING DESIGN (DED)
TAMBAK UPT

LOKASI

DESA DATA, KEC. DUAM PANUA
KAB. PINRANG, PROV. SULAWESI SELATAN

REVISI

NO	TGL	LOKASI	GMBR	DICEK	DISETUJUI

KONSULTAN PERENCANA



PT. DUTA Cipta Mandiri Engineering Consultant

AND IN SUB CONSULTANCY WITH



PT. SUCOFINDO ADVISORY UTAMA



PT, INAME UTAMA



PT. CAKRA BUANA AGHNA

DISUSUN :




Dr. Ir. BAMBANG SUMARTONO, M.Sc.
Aquaculture Specialist (Team Leader) (AQS/TL)

DISETUJUI :

PEJABAT PEMBUAT KOMITMEN
INFRASTRUCTURE IMPROVEMENT OF SHRIMP AQUACULTURE PROJECT


SOLEHUDIN ABDUL GANI, S.P
NIP. 19700727 200112 1 001

JUDUL GAMBAR		SKALA
DETAIL ELEVASI PIPA		1 : 20
KODE GAMBAR	NAL GAMBAR	TAHUN
LDK-07.11	-	2024

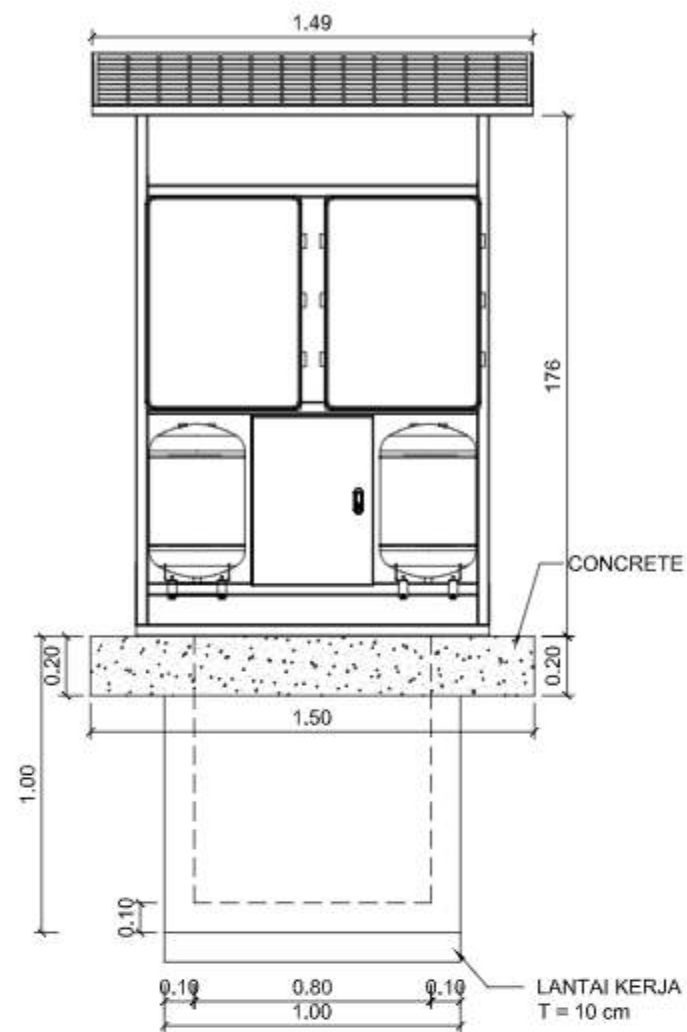


TAMPAK DEPAN

SKALA 1 : 25

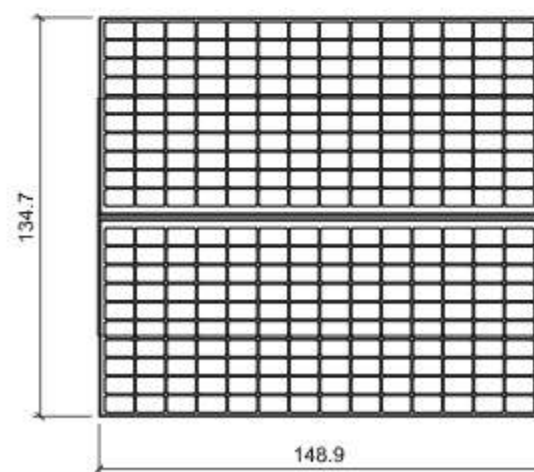


TAMPAK ATAS

SKALA 1 : 25

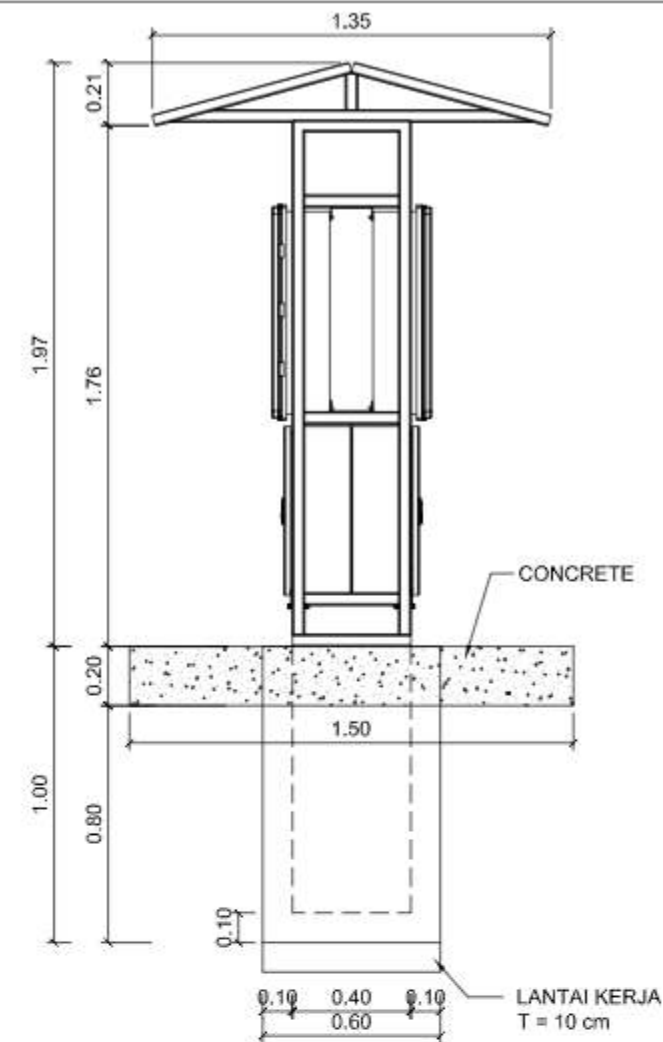

TAMPAK SAMPING

SKALA 1 : 25

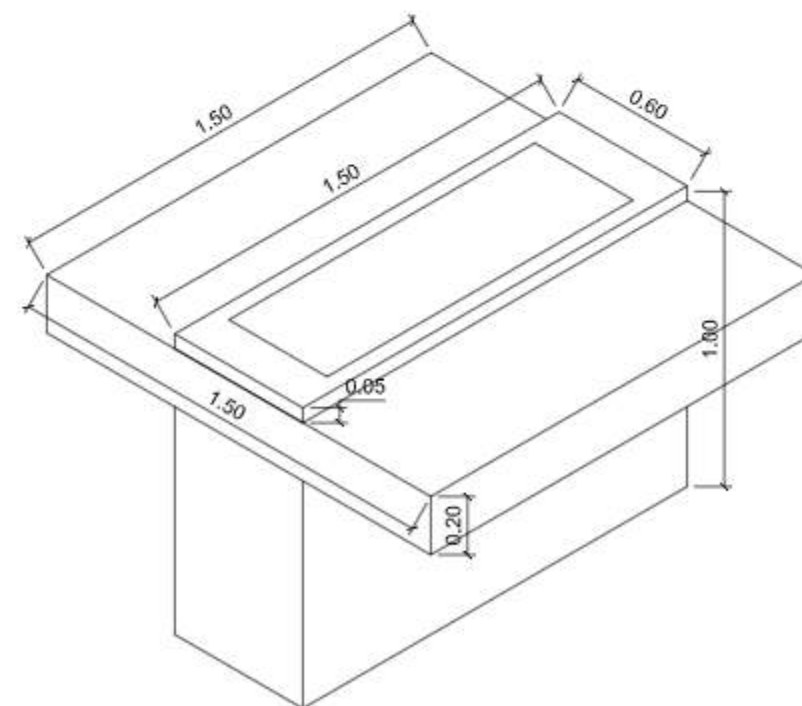

ISOMETRI

SKALA 1 : 25

PEMBERI TUGAS



KEMENTERIAN KELAUTAN DAN PERIKANAN
DIREKTORAT JENDERAL PERIKANAN BUDI DAYA
INFRASTRUCTURE IMPROVEMENT OF SHRIMP AQUACULTURE PROJECT (ISAP)
JALAN MEDAN MERDEKA TRAJUR NOMOR 16
JAKARTA 10110 KOTAK POS 4190 JKP 10041
TELEPON (021) 2510719 ILACAK, PAKSIBELE (021) 2514772
LAMAN www.kkp.go.id SUREL id@kpp.go.id

PEKERJAAN

GAMBAR DETAIL ENGINEERING DESIGN (DED)
TAMBAK UPT

LOKASI

DESA DATA, KEC. DUAM PANUA
KAB. PINRANG, PROV. SULAWESI SELATAN

REVISI

NO	TGL	LOKASI	GMBR	DICEK	DISETUJUI

KONSULTAN PERENCANA



PT. DUTA CIPTA MANDIRI ENGINEERING CONSULTANT

AND IN SUB CONSULTANCY WITH



PT. SUCOFINDO ADVISORY UTAMA



PT. INAME UTAMA



PT. CAKRA BUANA AGHNA

DISUSUN :

[Signature]

Dr. Ir. BAMBANG SUMARTONO, M.Sc.
Aquaculture Specialist (Team Leader) [AQSTL]

DISETUJUI :

PEJABAT PEMBUAT KOMITMEN
INFRASTRUCTURE IMPROVEMENT OF SHRIMP AQUACULTURE PROJECT

[Signature]

SOLEHUJUDIN ABDUL GANI, S.Pi
NIP. 19700727 200112 1 001

JUDUL GAMBAR		SKALA
DETAIL QUALITY MONITORING		1 : 25
KODE GAMBAR	HAL GAMBAR	TAHUN
LDK-07.13	-	2024